
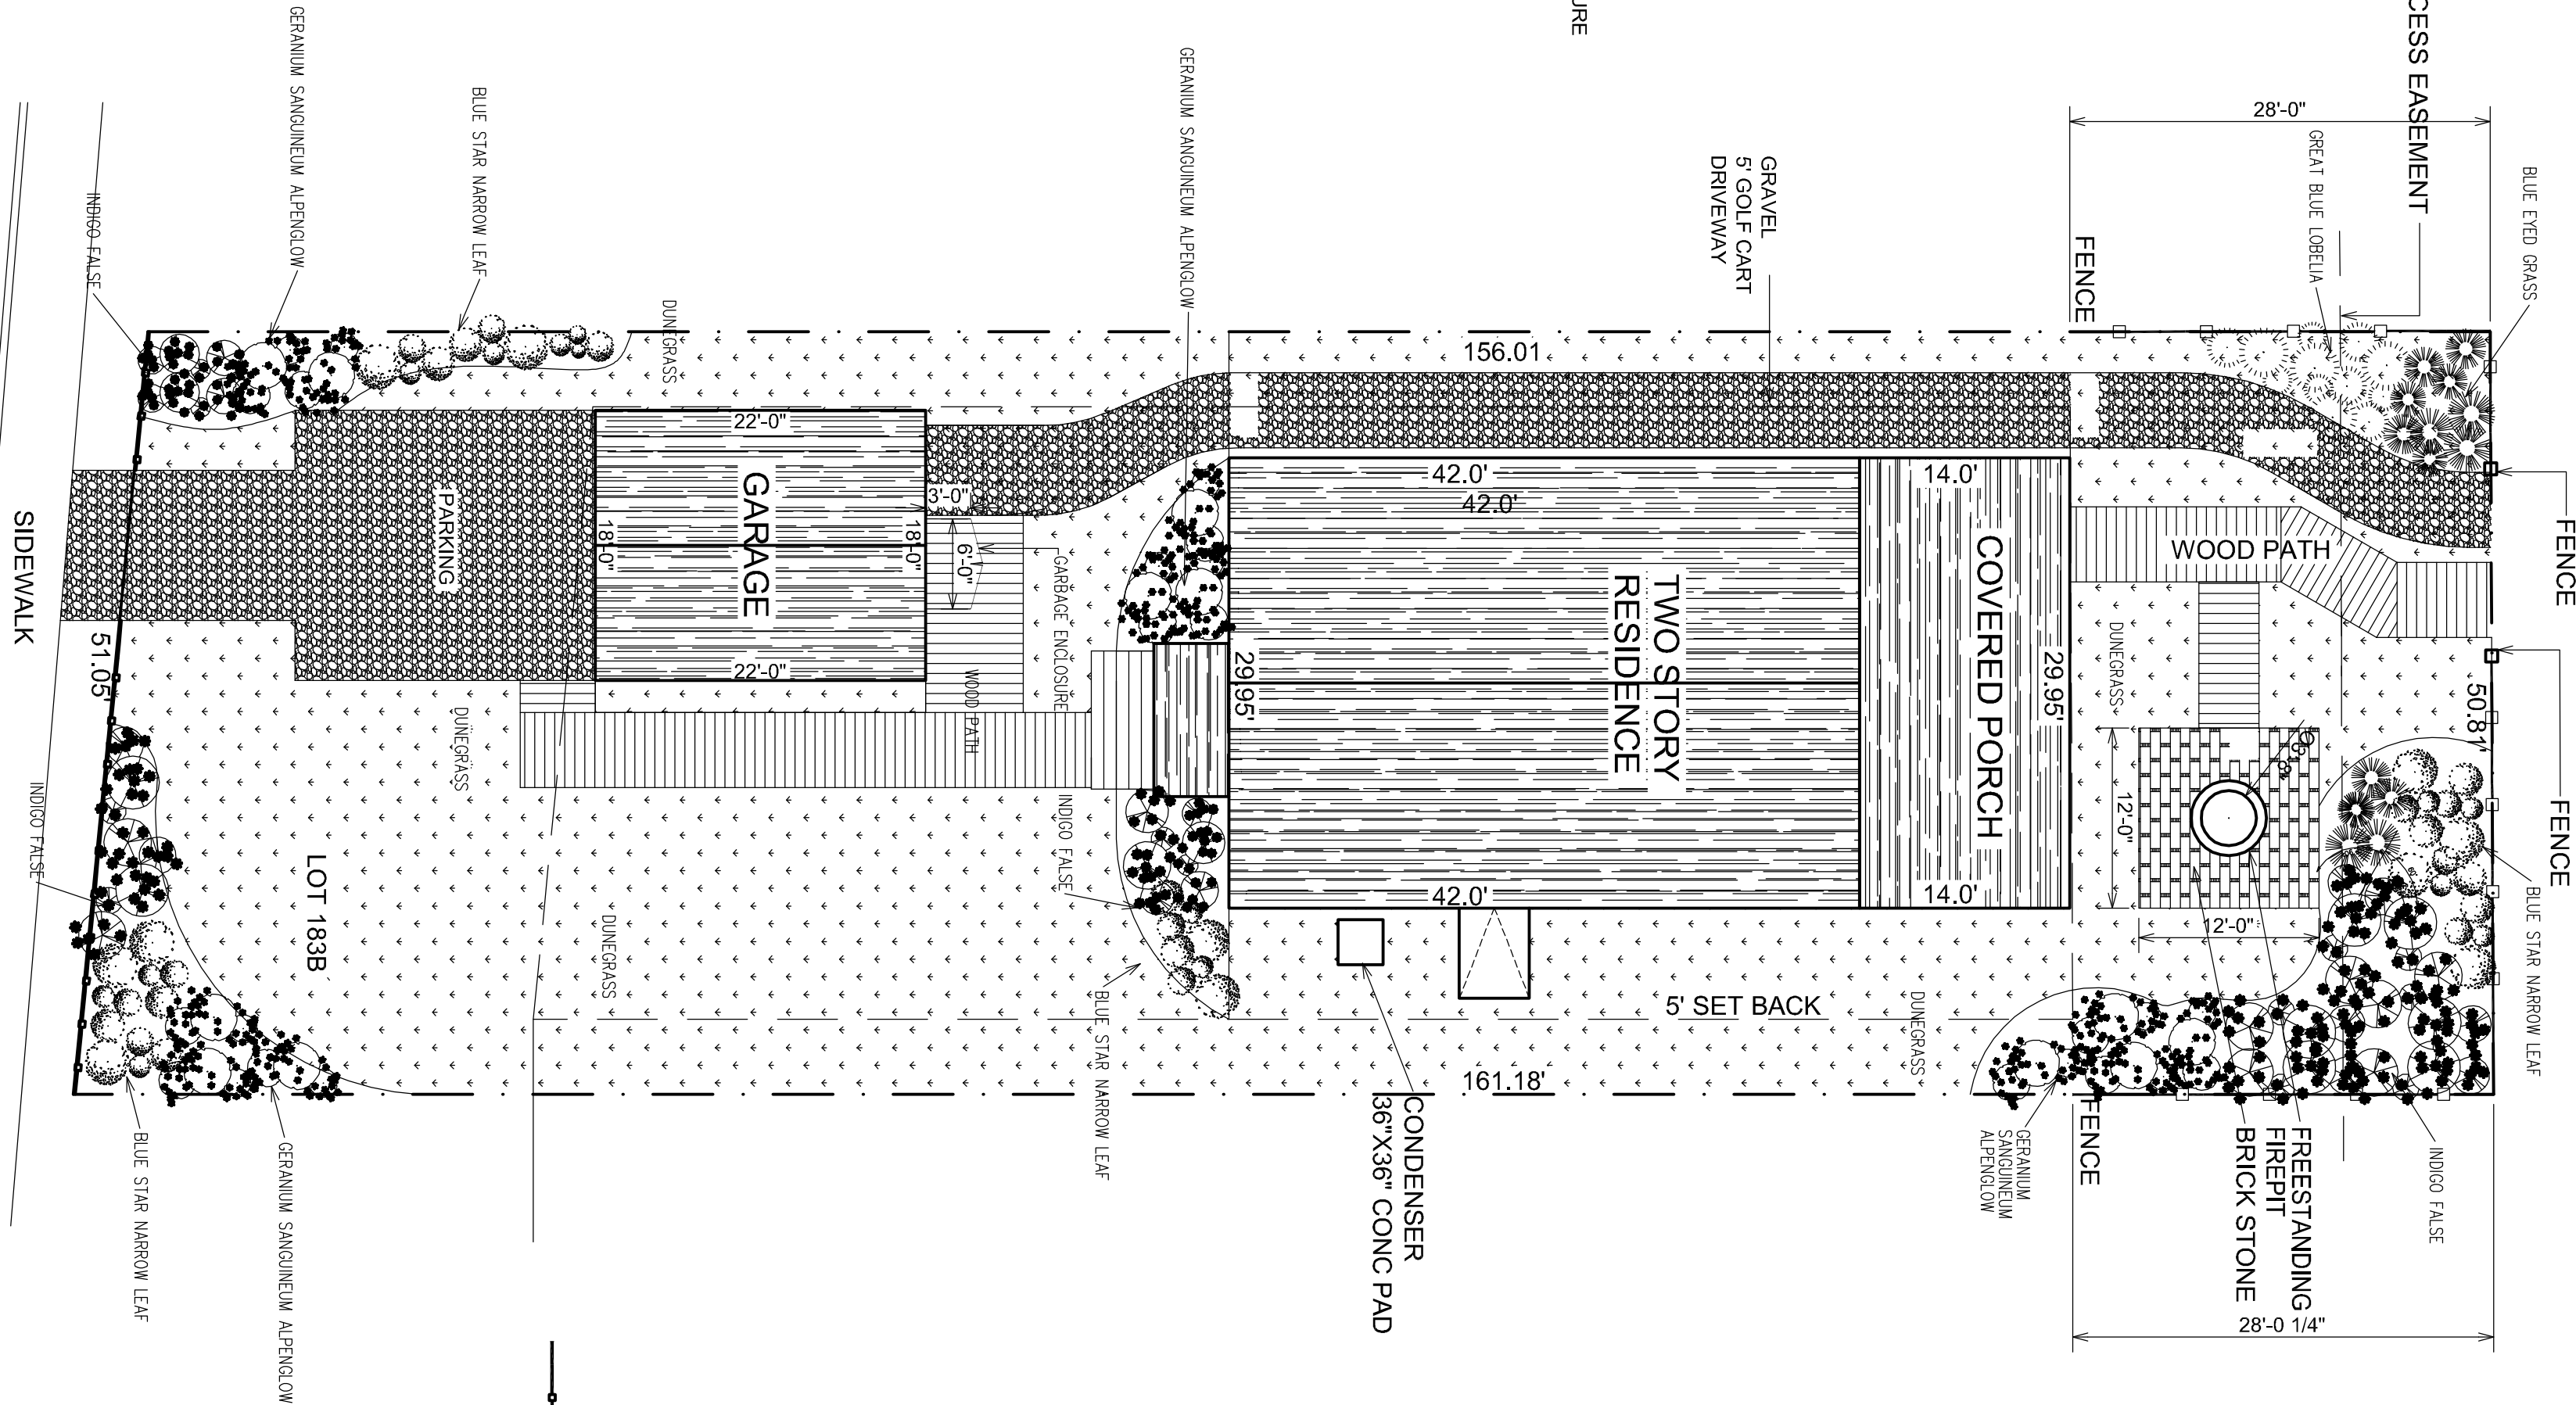


ARIES

LOT 183 B JAKE LANE CASON PARK BEACHWOOD NEIGHBORHOOD, BEACHWALK MICHIGAN CITY INDIANA 46360

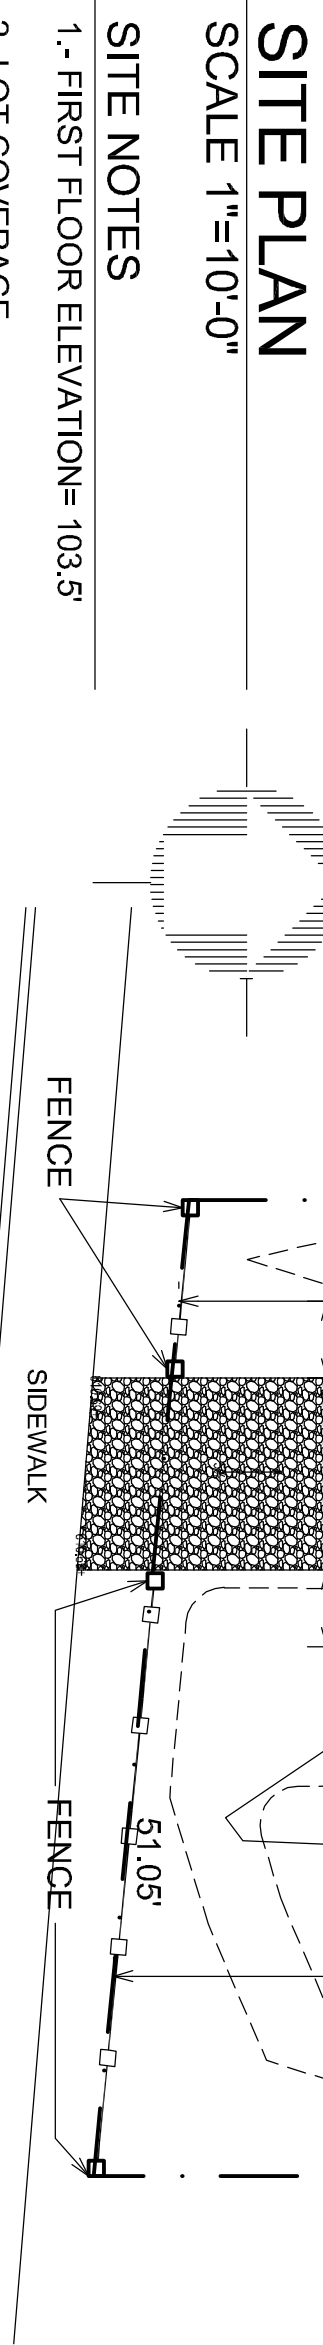

CENTER LINE OF WASHINGTON BOULEVARD


LANDSCAPE PLAN
SCALE 1/4"=1'-0"

GENERAL NOTES:

- 1). ALL LABOR AND MATERIALS SHALL CONFORM TO ALL FEDERAL, STATE AND LOCAL BUILDING CODES, INDUSTRY STANDARDS AND MANUFACTURERS' SPECIFICATIONS.
- 2). CONTRACTOR TO BE RESPONSIBLE FOR MAINTAINING A SAFE AND CLEAN SITE TO AVOID INJURY OR DAMAGE TO PEOPLE, MATERIALS AND BUILDINGS.
- 3). CONTRACTOR TO PERFORM ALL WORK REQUIRED TO COMPLETE WORK AS AWARDED, TO FURNISH ALL LABOR, TOOLS, MATERIALS, EQUIPMENT, TRANSPORTATION, SERVICES, BONDS, INSURANCE AND WARRANTIES REQUIRED TO PERFORM AND COMPLETE THE CONTRACTED PROJECT IN A WORKMAN-LIKE AND TIMELY MANNER.
- 4). CONTRACTOR SHALL EXAMINE SITE AND DRAWINGS AND BE RESPONSIBLE FOR EXISTING AND ON-GOING SITE CONDITIONS AND COORDINATION OF ABOVE.
- 5). ALL LABOR AND MATERIALS WILL BE SUBJECT TO ARCHITECT APPROVAL BASED ON PLANS, SPECIFICATIONS AND STANDARD CONSTRUCTION PRACTICES.
- 6). DRAWINGS ARE MEANT TO REFLECT APPROXIMATE EXISTING AND FINISHED CONDITIONS. DO NOT SCALE DRAWINGS.
- 7). ALL DIMENSIONS ON STRUCTURAL DRAWINGS TO BE CHECKED AGAINST ALL EXISTING AND PROPOSED ARCHITECTURAL AND MECHANICAL CONDITIONS. ANY DISCREPANCIES ARE TO BE IMMEDIATELY REPORTED TO THE ARCHITECT.
- 8). UNLESS NOTED AS OTHERWISE, ALL DETAILS AND NOTES ON DRAWINGS ARE TYPICAL.
- 9). DRAWINGS ARE NOT INTENDED TO BE USED AS SHOP DRAWINGS, UNLESS NOTED AS OTHERWISE.
- 10). WRITTEN ARCHITECT APPROVAL MUST BE OBTAINED FOR ALL CHANGES AND SUBSTITUTIONS.
- 11). ALL DRAWINGS REMAIN THE PROPERTY OF THE ARCHITECT. INFORMATION CONTAINED IN THE STRUCTURAL DRAWINGS ARE INCOMPLETE AND VOID UNLESS USED IN CONJUNCTION WITH ALL CONTRACT DOCUMENTS AND ALL SPECIFICATIONS, TRADE PRACTICES, ACCEPTABLE CODES AND STANDARDS, ETC. INCORPORATED THEREIN BY REFERENCE WHICH THE CONTRACTOR CERTIFIES KNOWLEDGE OF SITE CONDITIONS SHALL BE REPORTED TO THE ARCHITECT AND WORK SHALL NOT CONTINUE WITHOUT THE ARCHITECT WRITTEN APPROVAL.
- 14). THE CONTRACTOR SHALL PAY FOR ALL PERMITS, LICENSING, AND/OR LEGAL FEES INCURRED IN SECURING LOCAL PERMISSION TO START CONSTRUCTION.
- 15). ALL FLAT AND STRUCTURAL CONCRETE WORK TO BE 3,500 PSI, 5 1/2 BAG MIX UNLESS OTHERWISE SPECIFIED.

LANDSCAPE LEGEND

- INDIGO FALSE
- GERANIUM SANGUINEUM ALPENGLOW
- GREAT BLUE LOBELIA (LOBELIA SIPHILTICA) #4 H
- BLUE EYED GRASS
- BLUE STAR NARROW LEAF
- DUNEGRASS
MARITIM GRASS (AMMOPHILA ARENARIA) 3'H
- WOOD PICKET FENCE

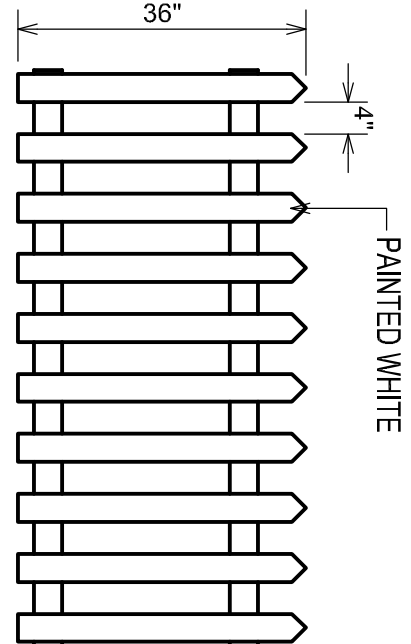

WOOD PICKET FENCE N.T.S.

KENNETH MUNGUIA ARELLANO
ARCHITECT
5610 WOLBERT AVENUE, PORTAGE IN 46368 (219) 763 6794

PROJECT TITLE

ARIES MODEL

SCALE


1"=10'-0"

DATE

AUG/23/2023


SHEET

1

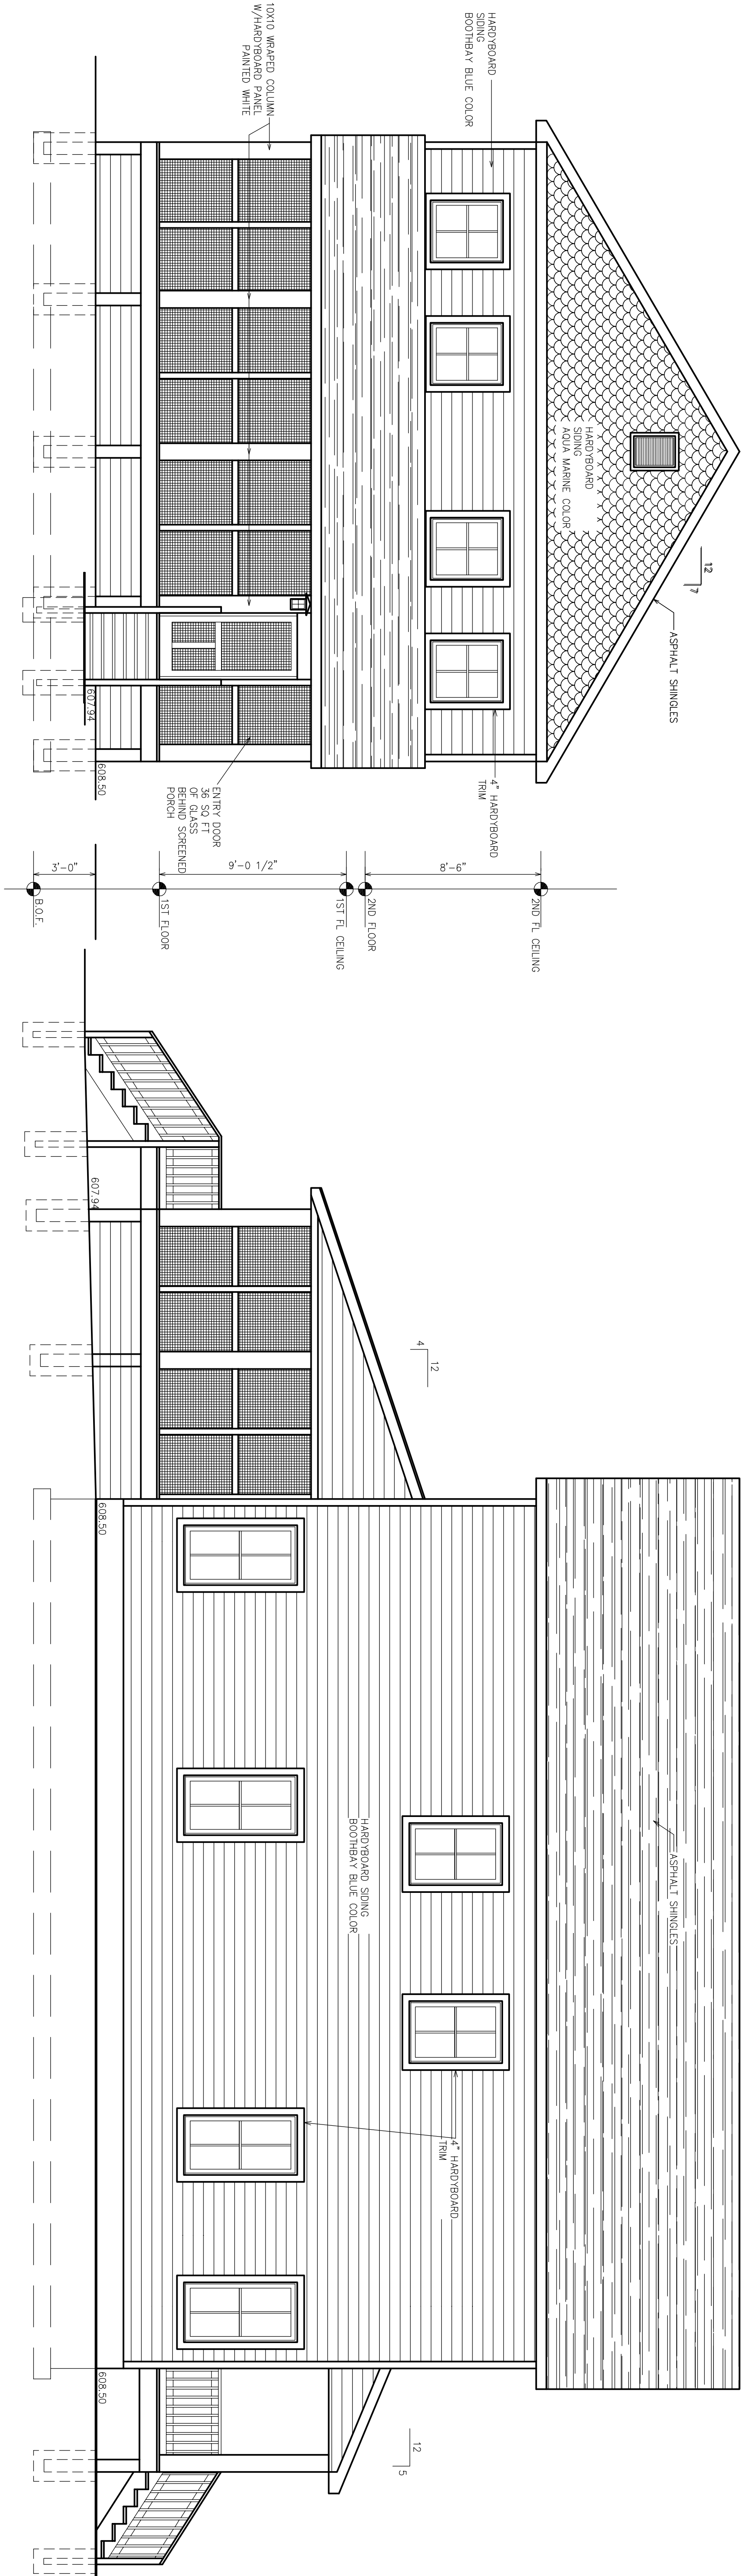


NORTH ELEVATION

SCALE 1/4"=1'-0"

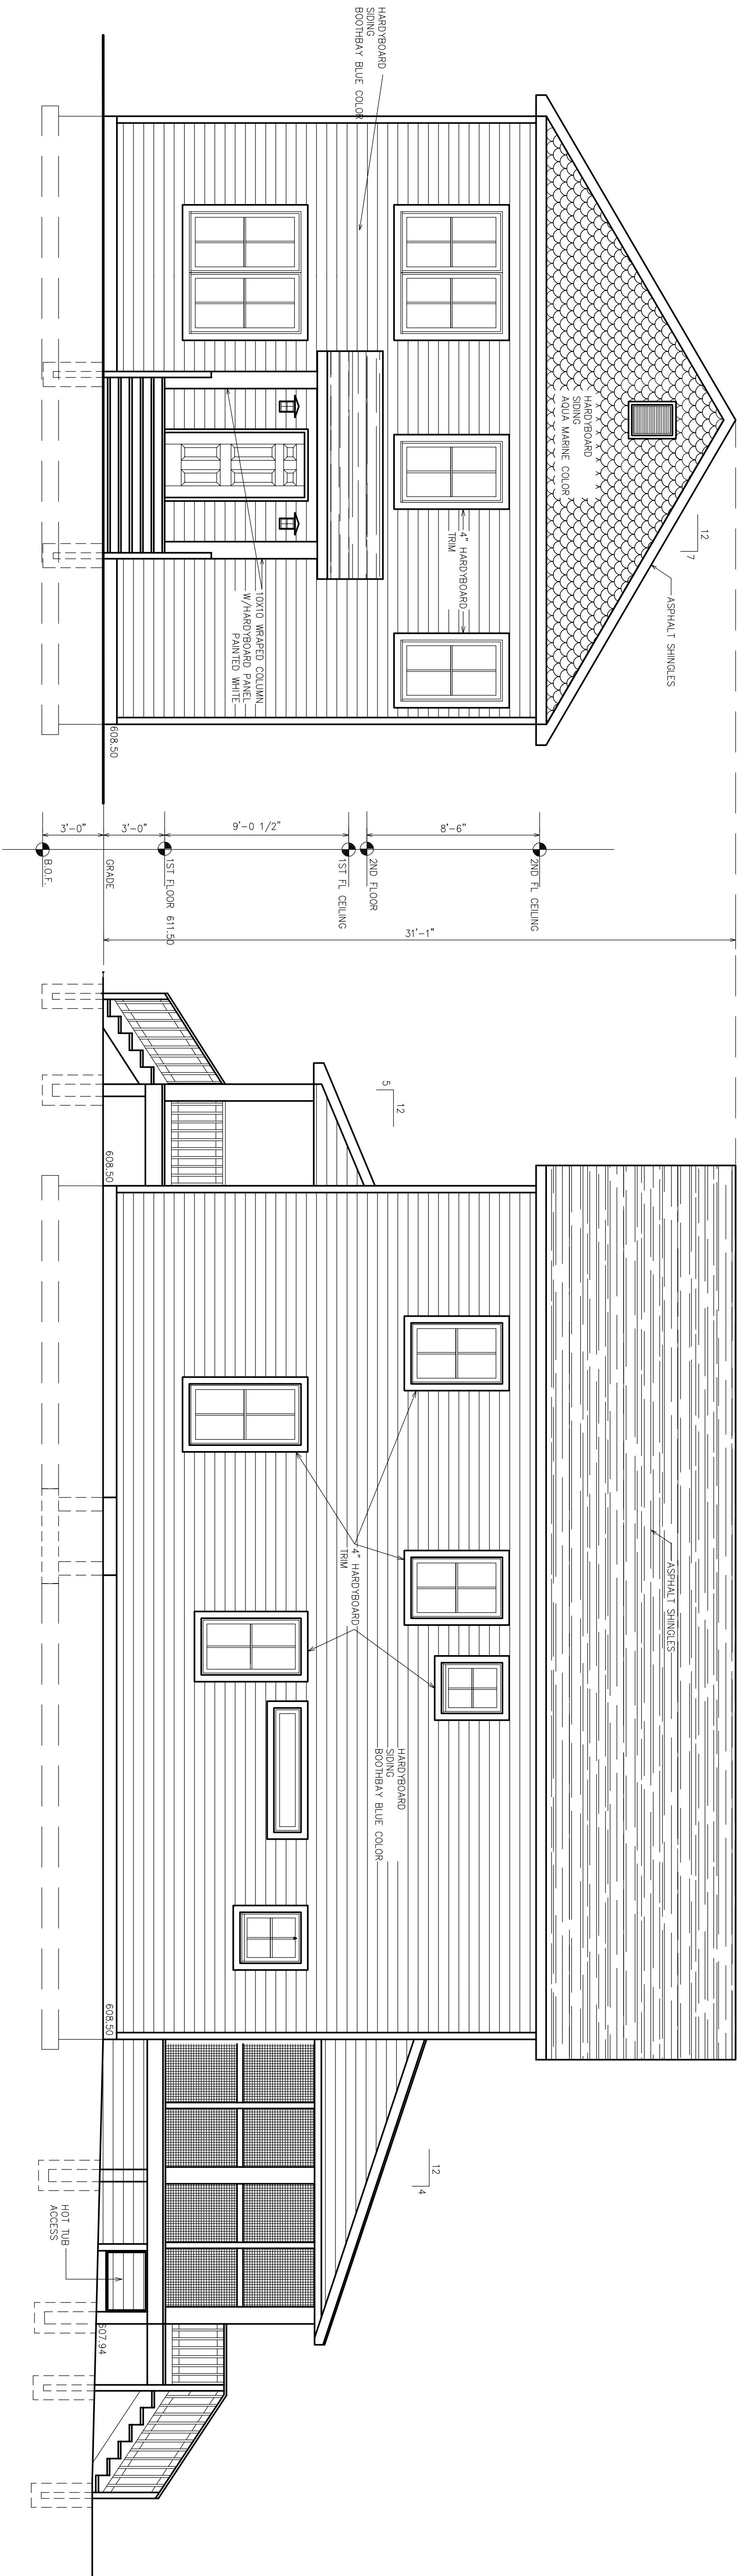


SOUTH ELEVATION

SCALE 1/4"=1'-0"

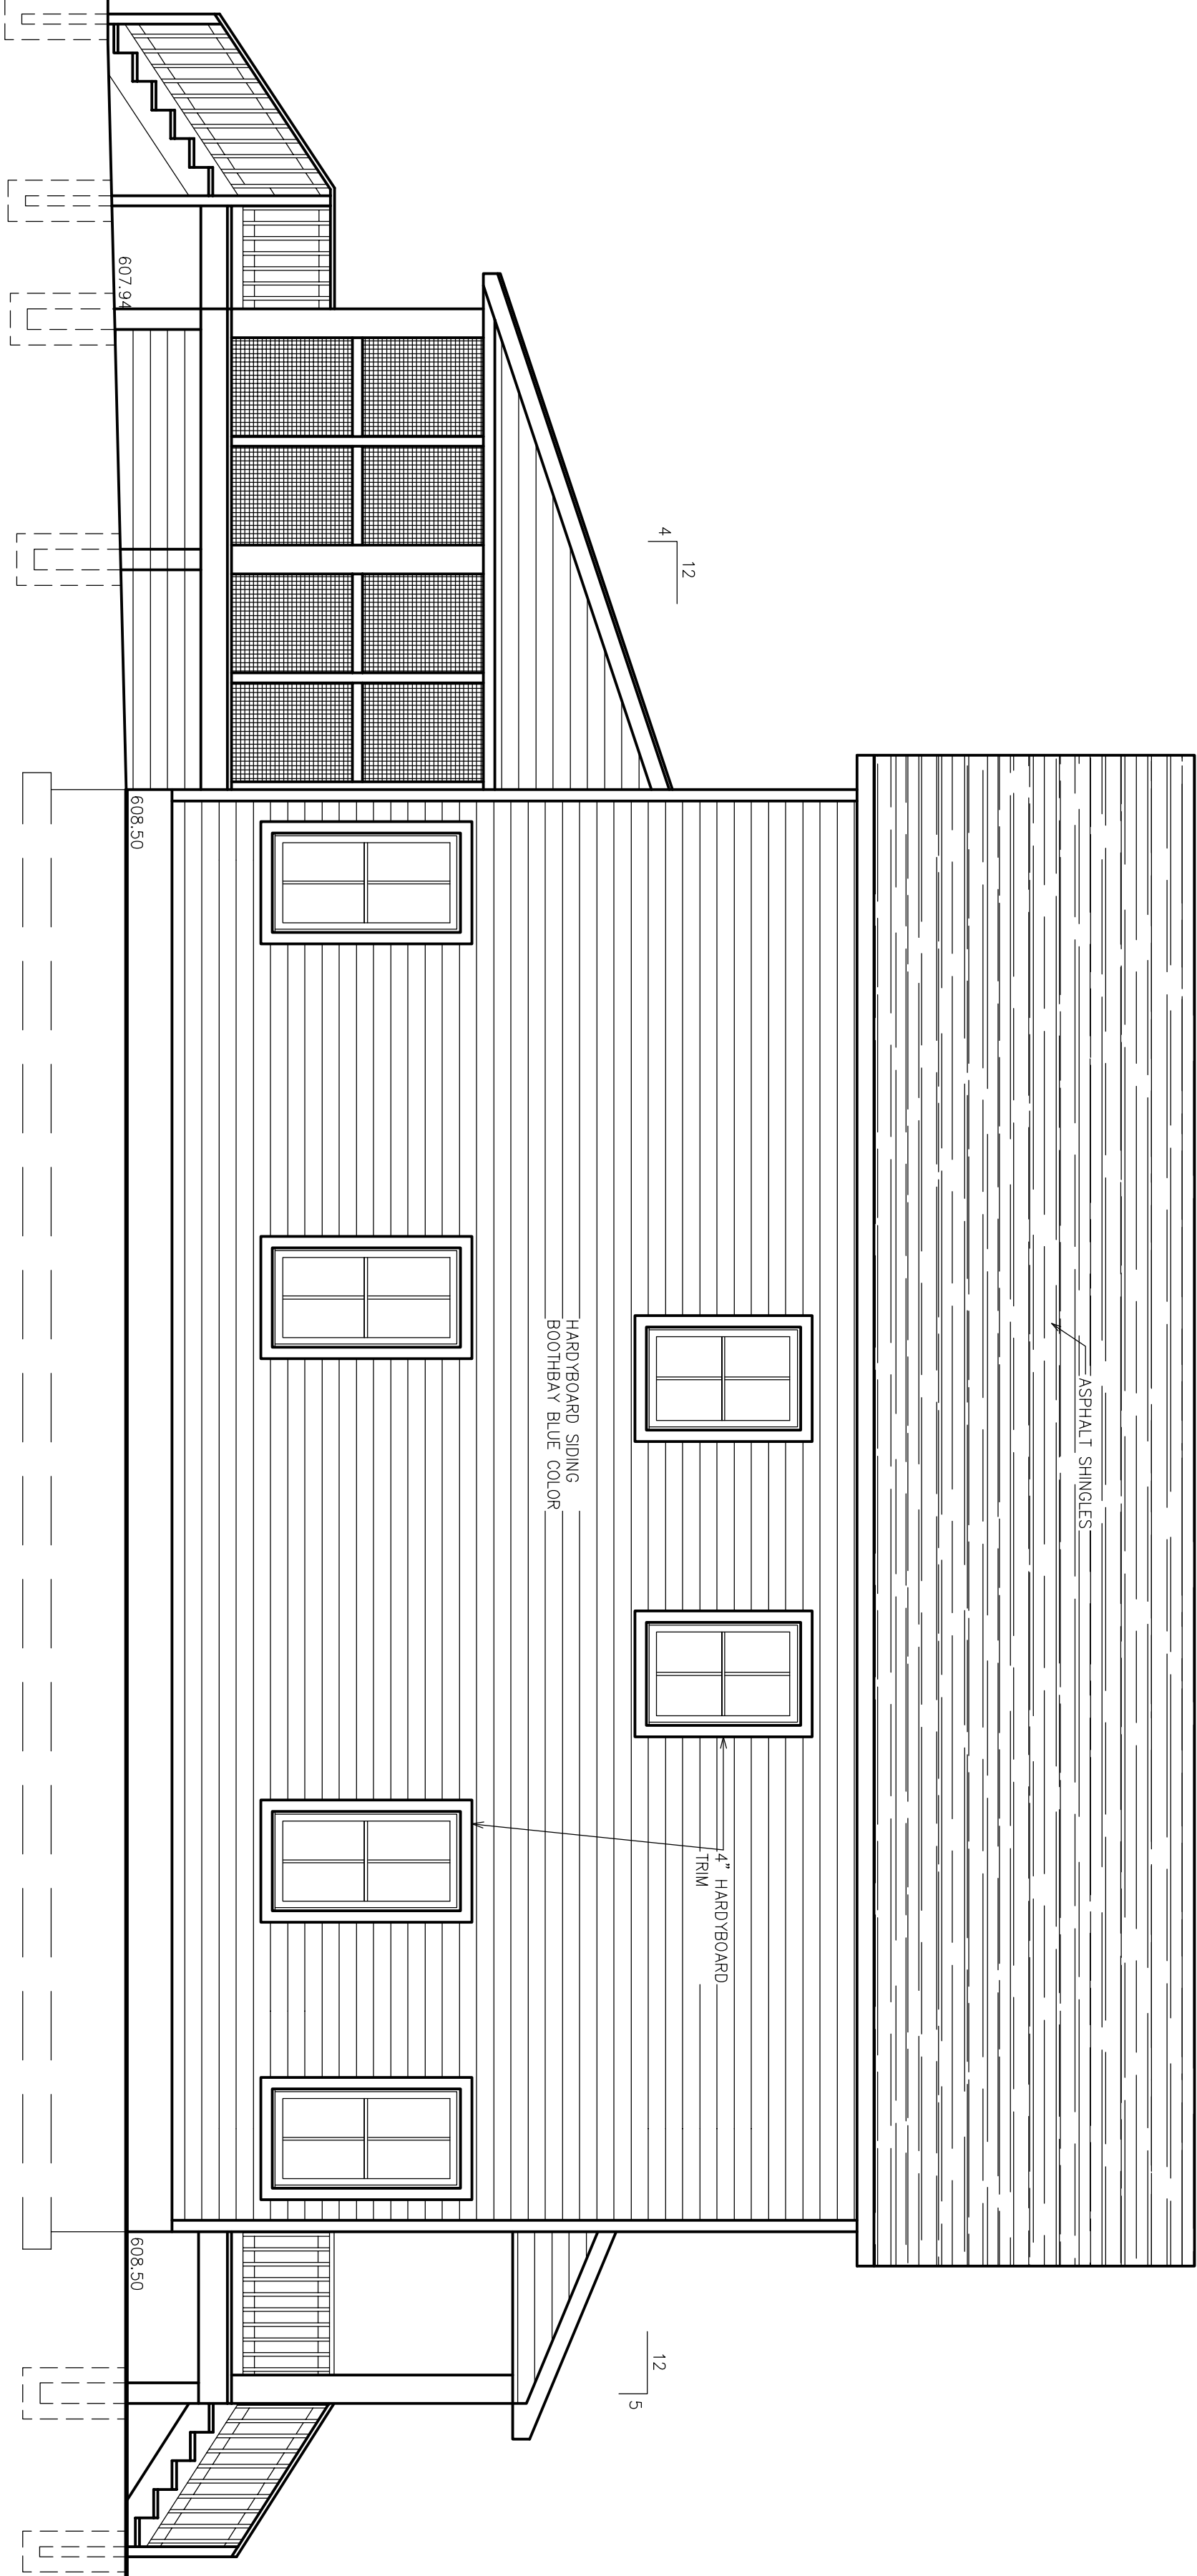

WEST ELEVATION










SCALE 1/4"=1'-0"

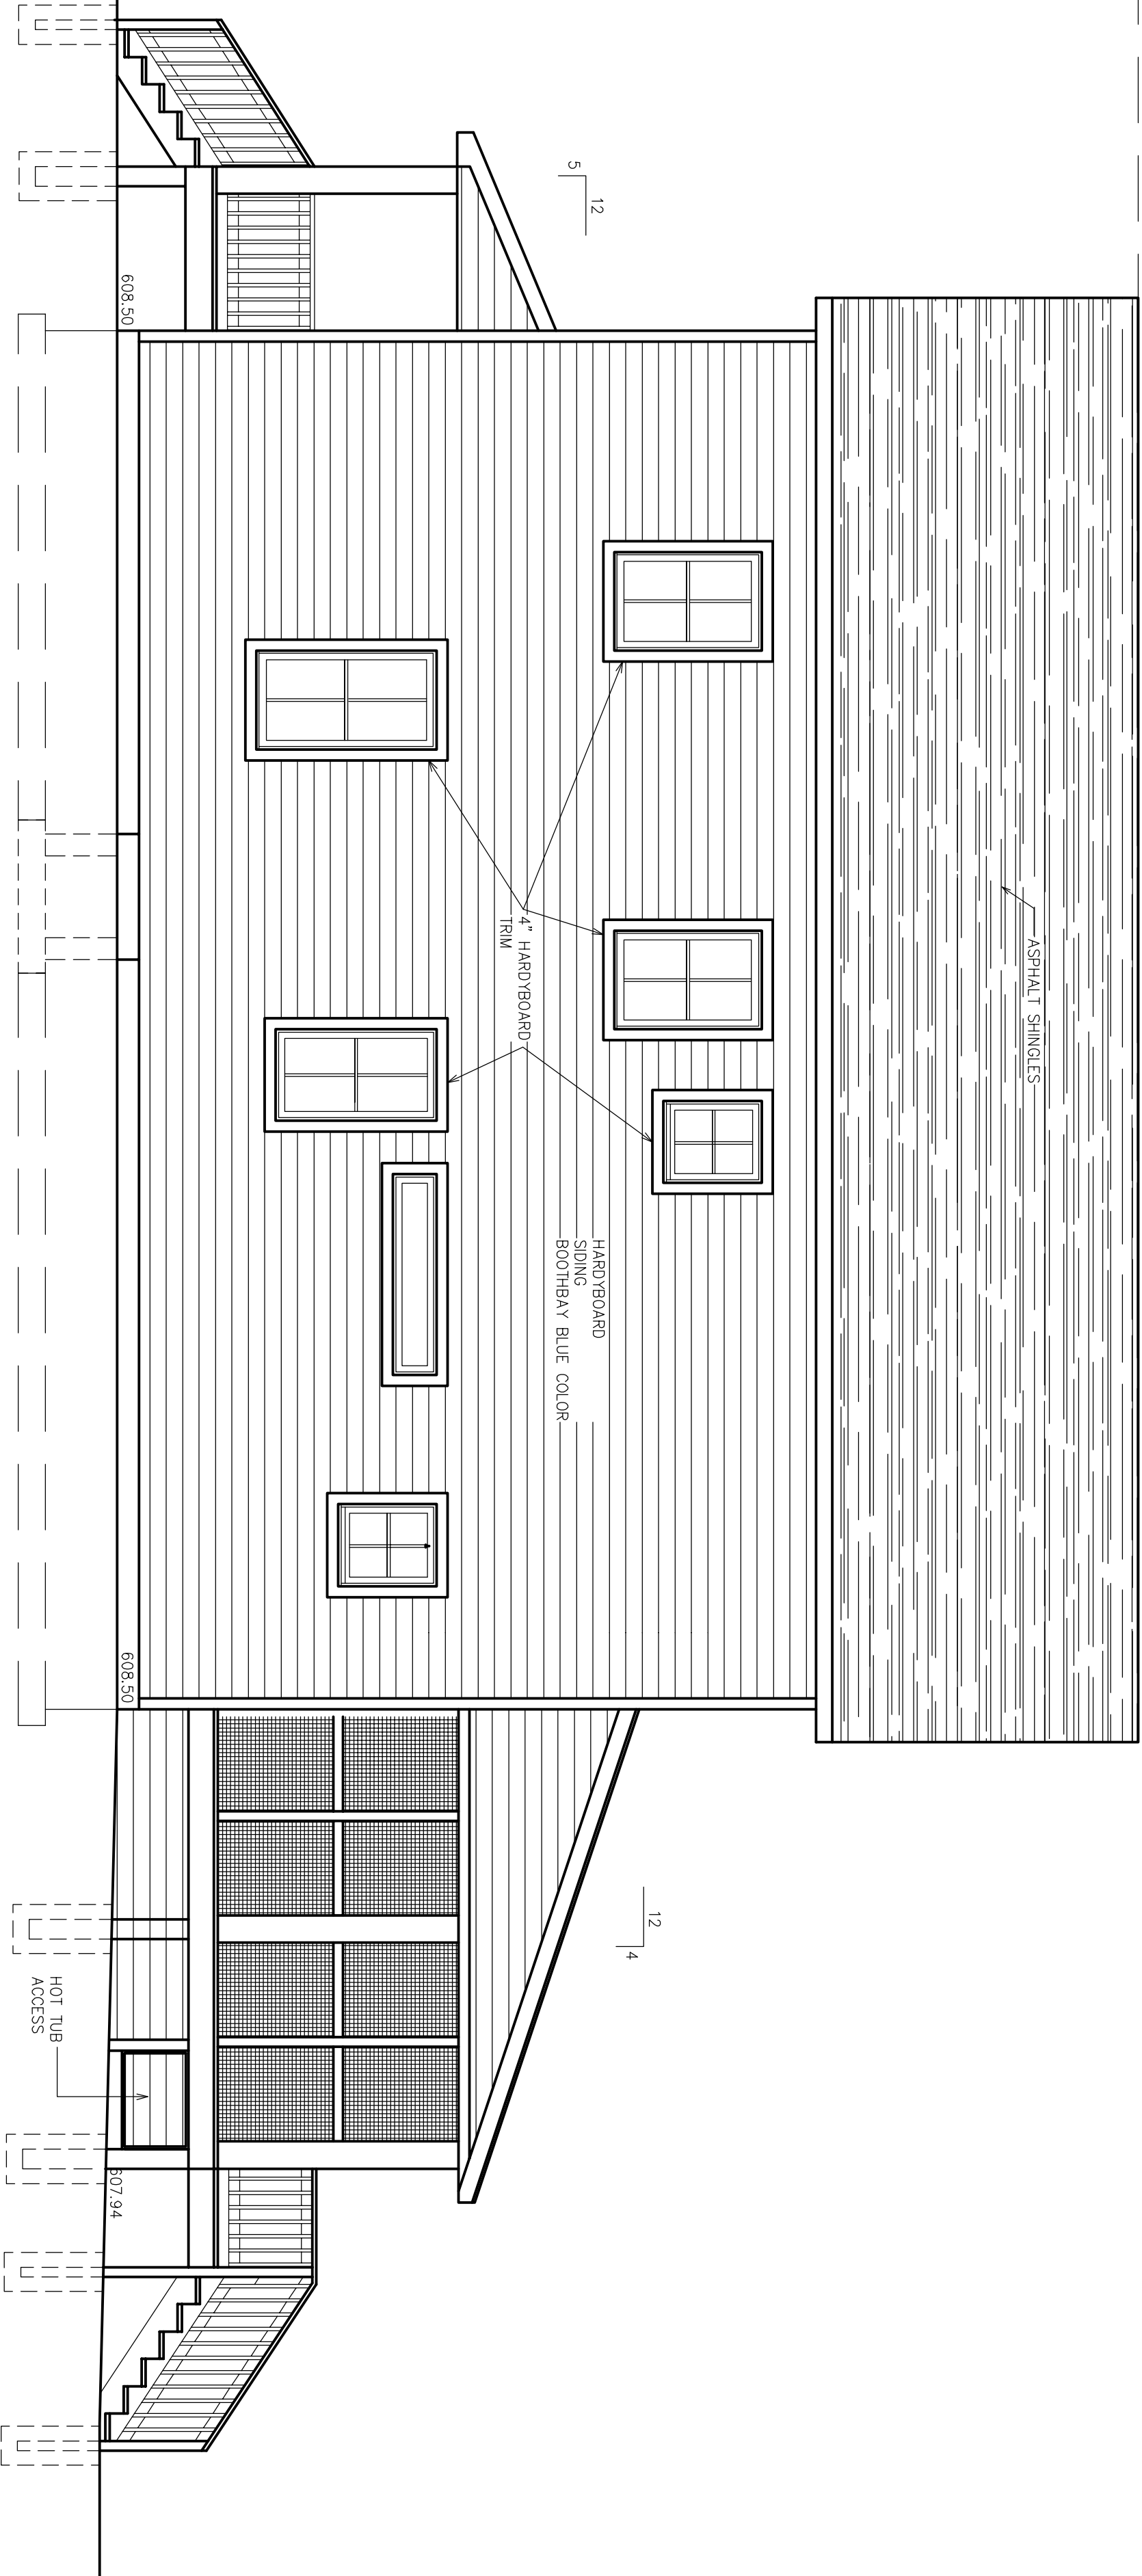


EAST ELEVATION

SCALE 1/4"=1'-0"

IRBA KENNETH MUNGUIA ARELLANO ARCHITECT 5610 WOLBERT AVENUE, PORTAGE IN 46368 (219) 763 6794			
PROJECT TITLE			
ARIES			
LOT 183 B JAKE LANE CASON PARK BEACHWOOD NEIGHBORHOOD, BEACHWALK MICHIGAN CITY INDIANA 46360			
SCALE	1 / 4 " = 1 ' - 0 "	DRAWN	KVIA
DATE	AUG / 23 / 2023	ELEVATIONS	
			SHEET
			2

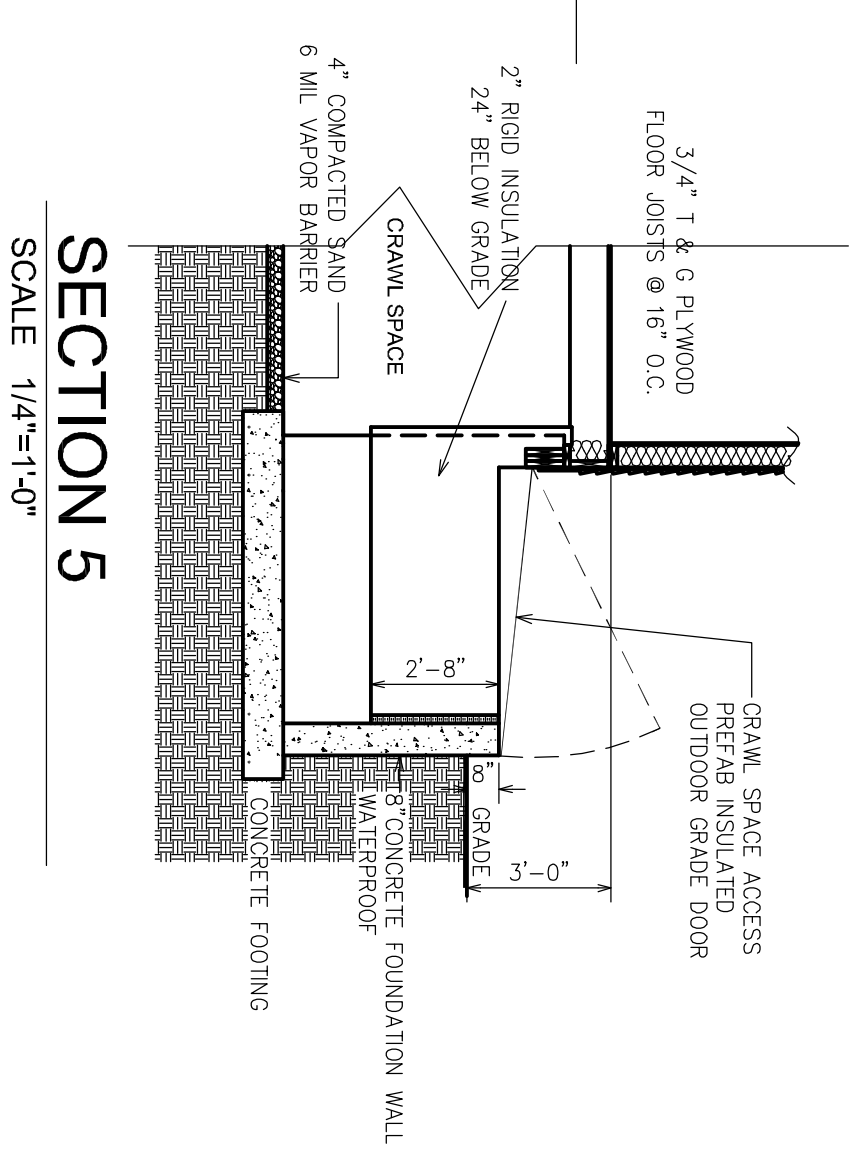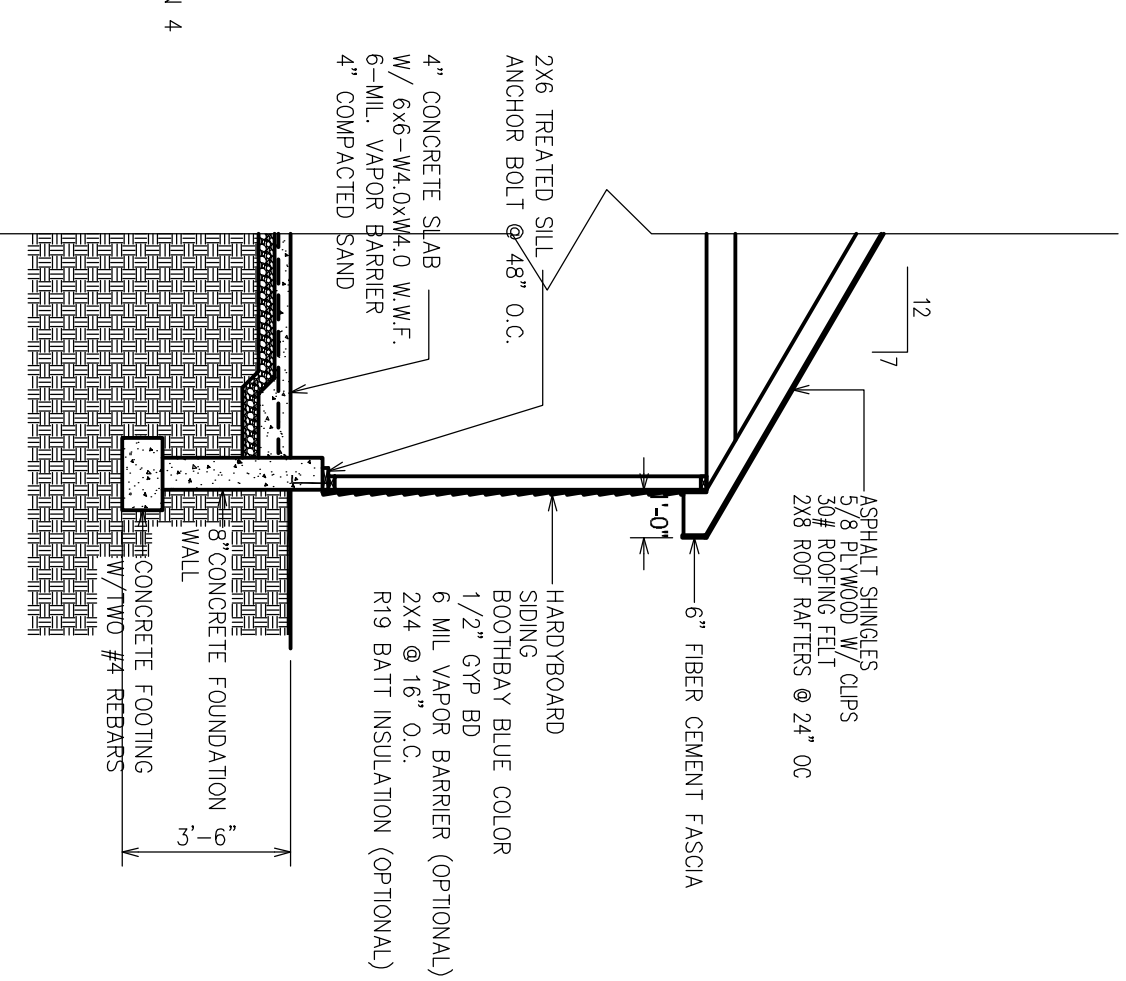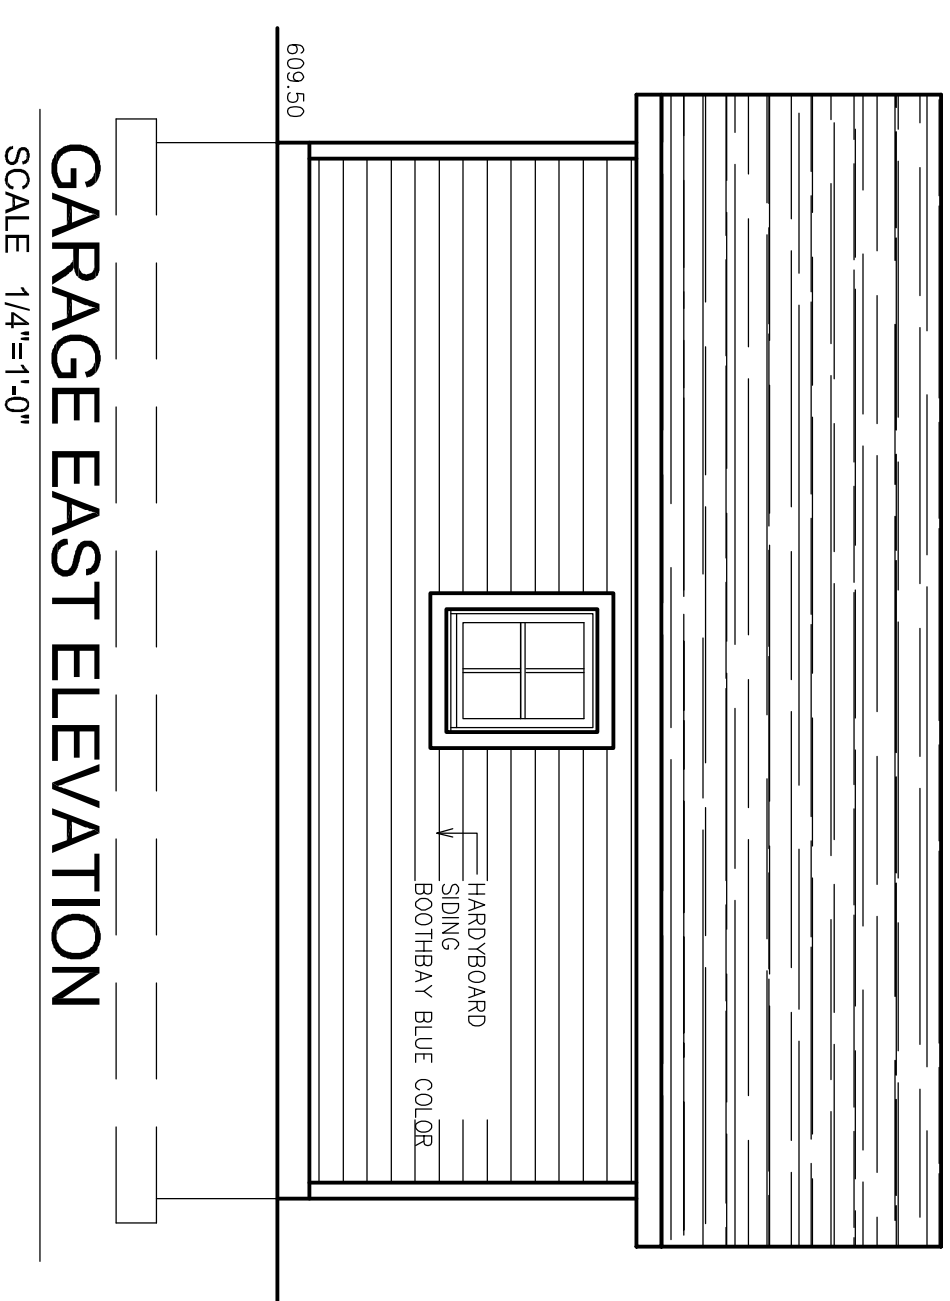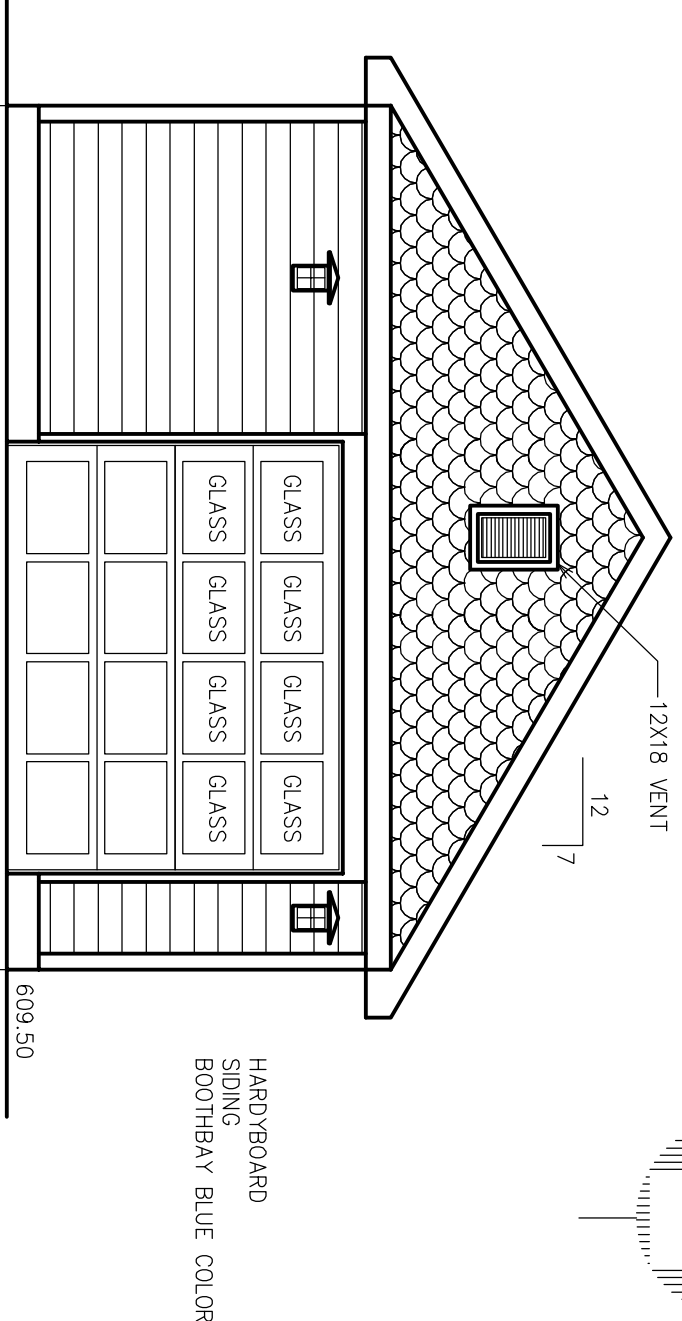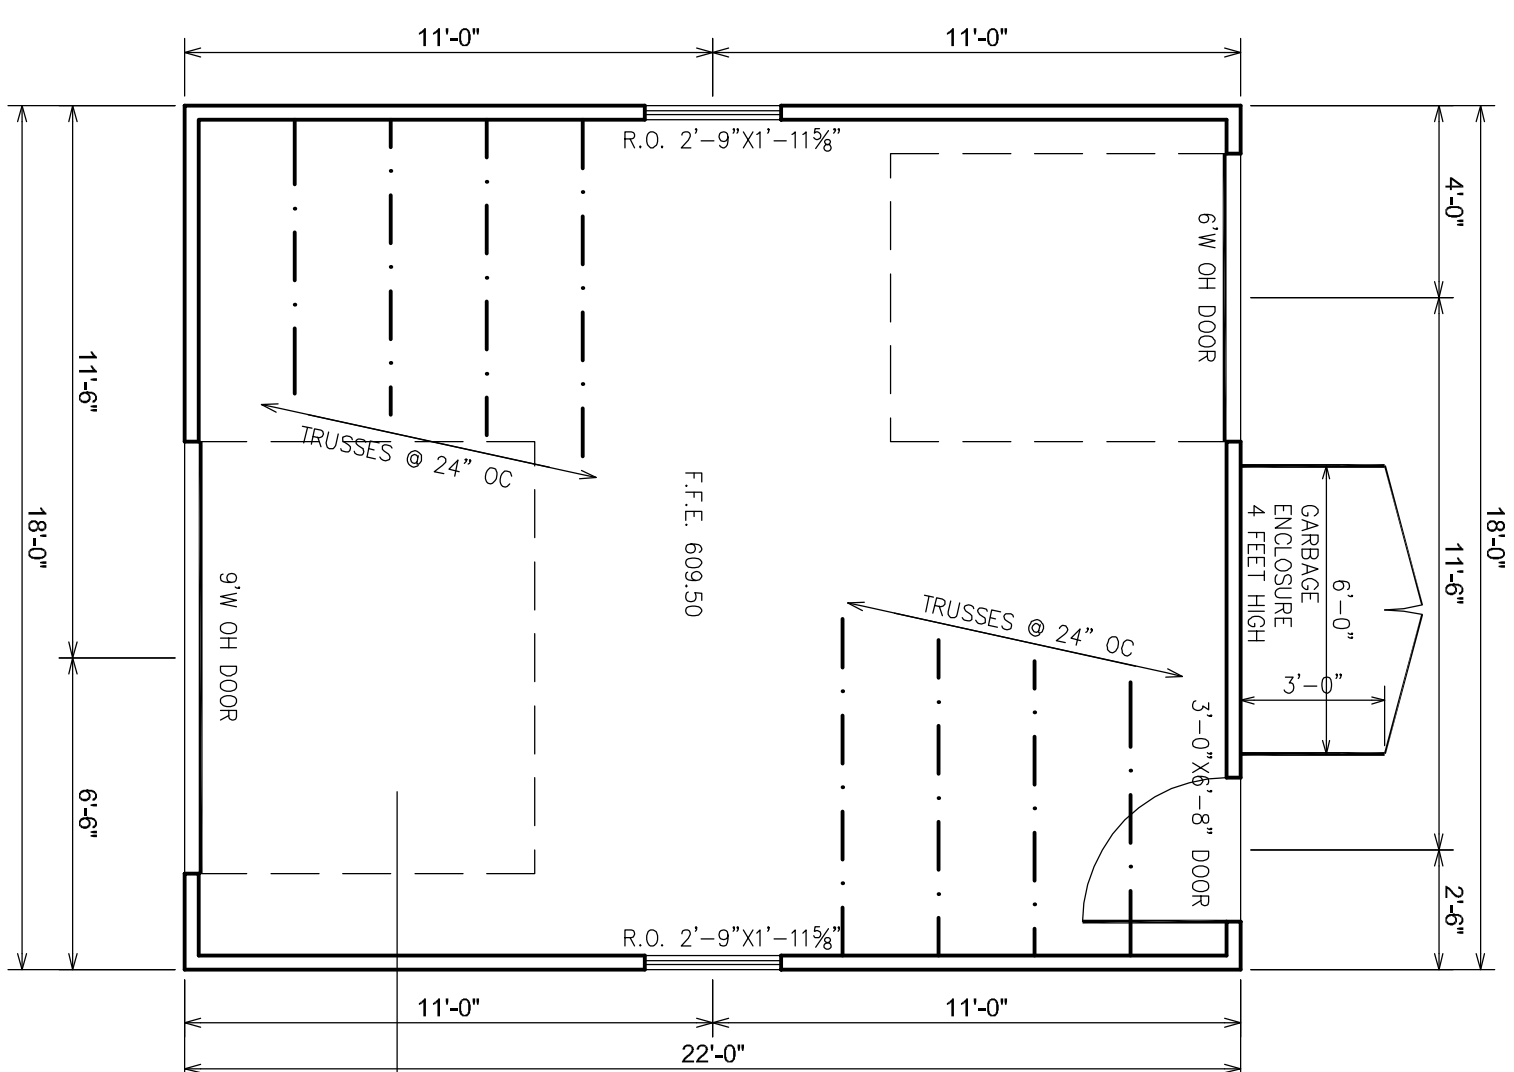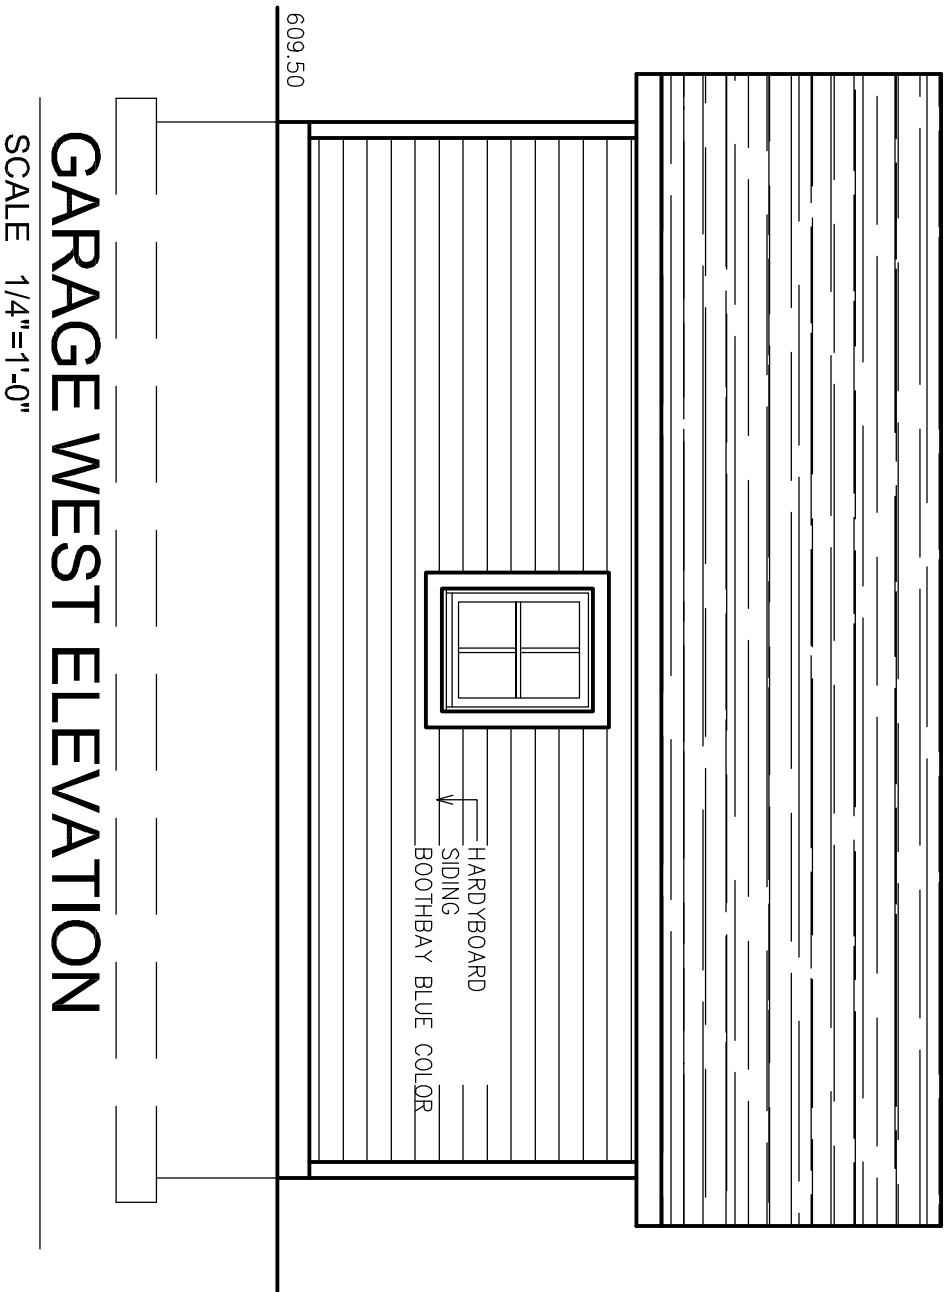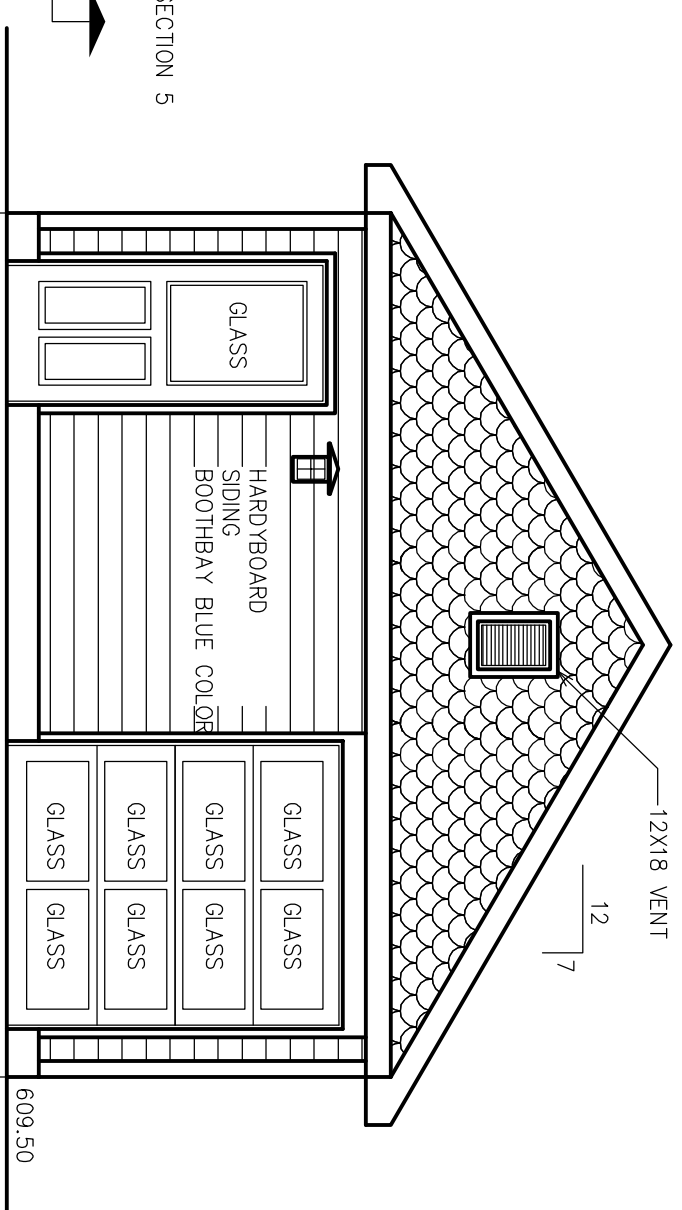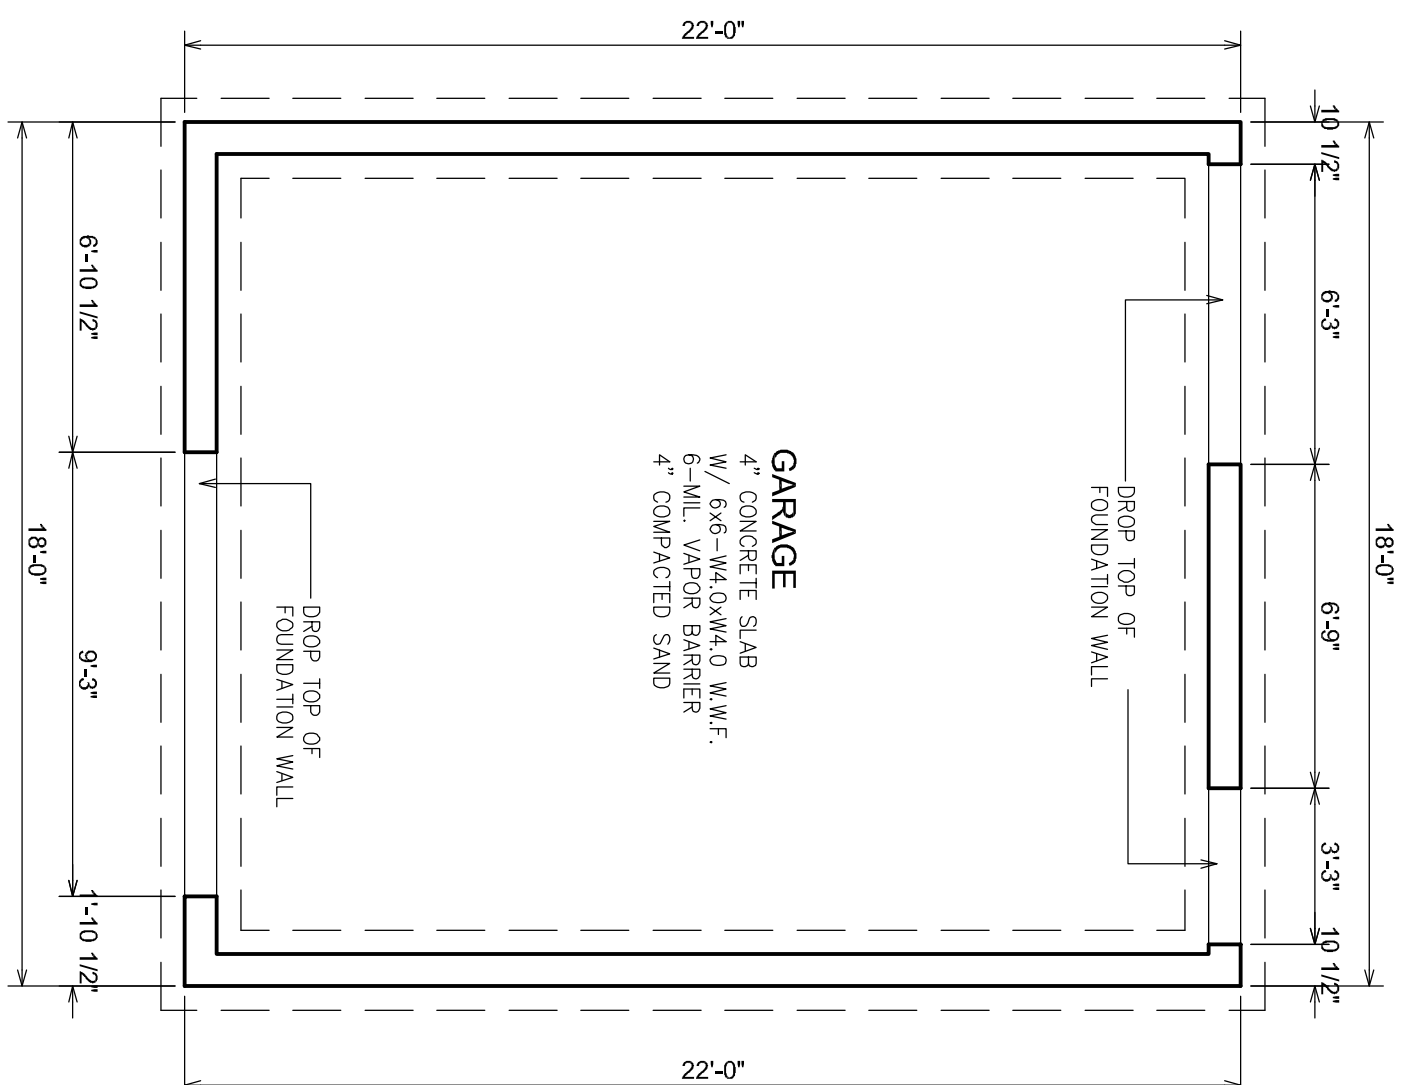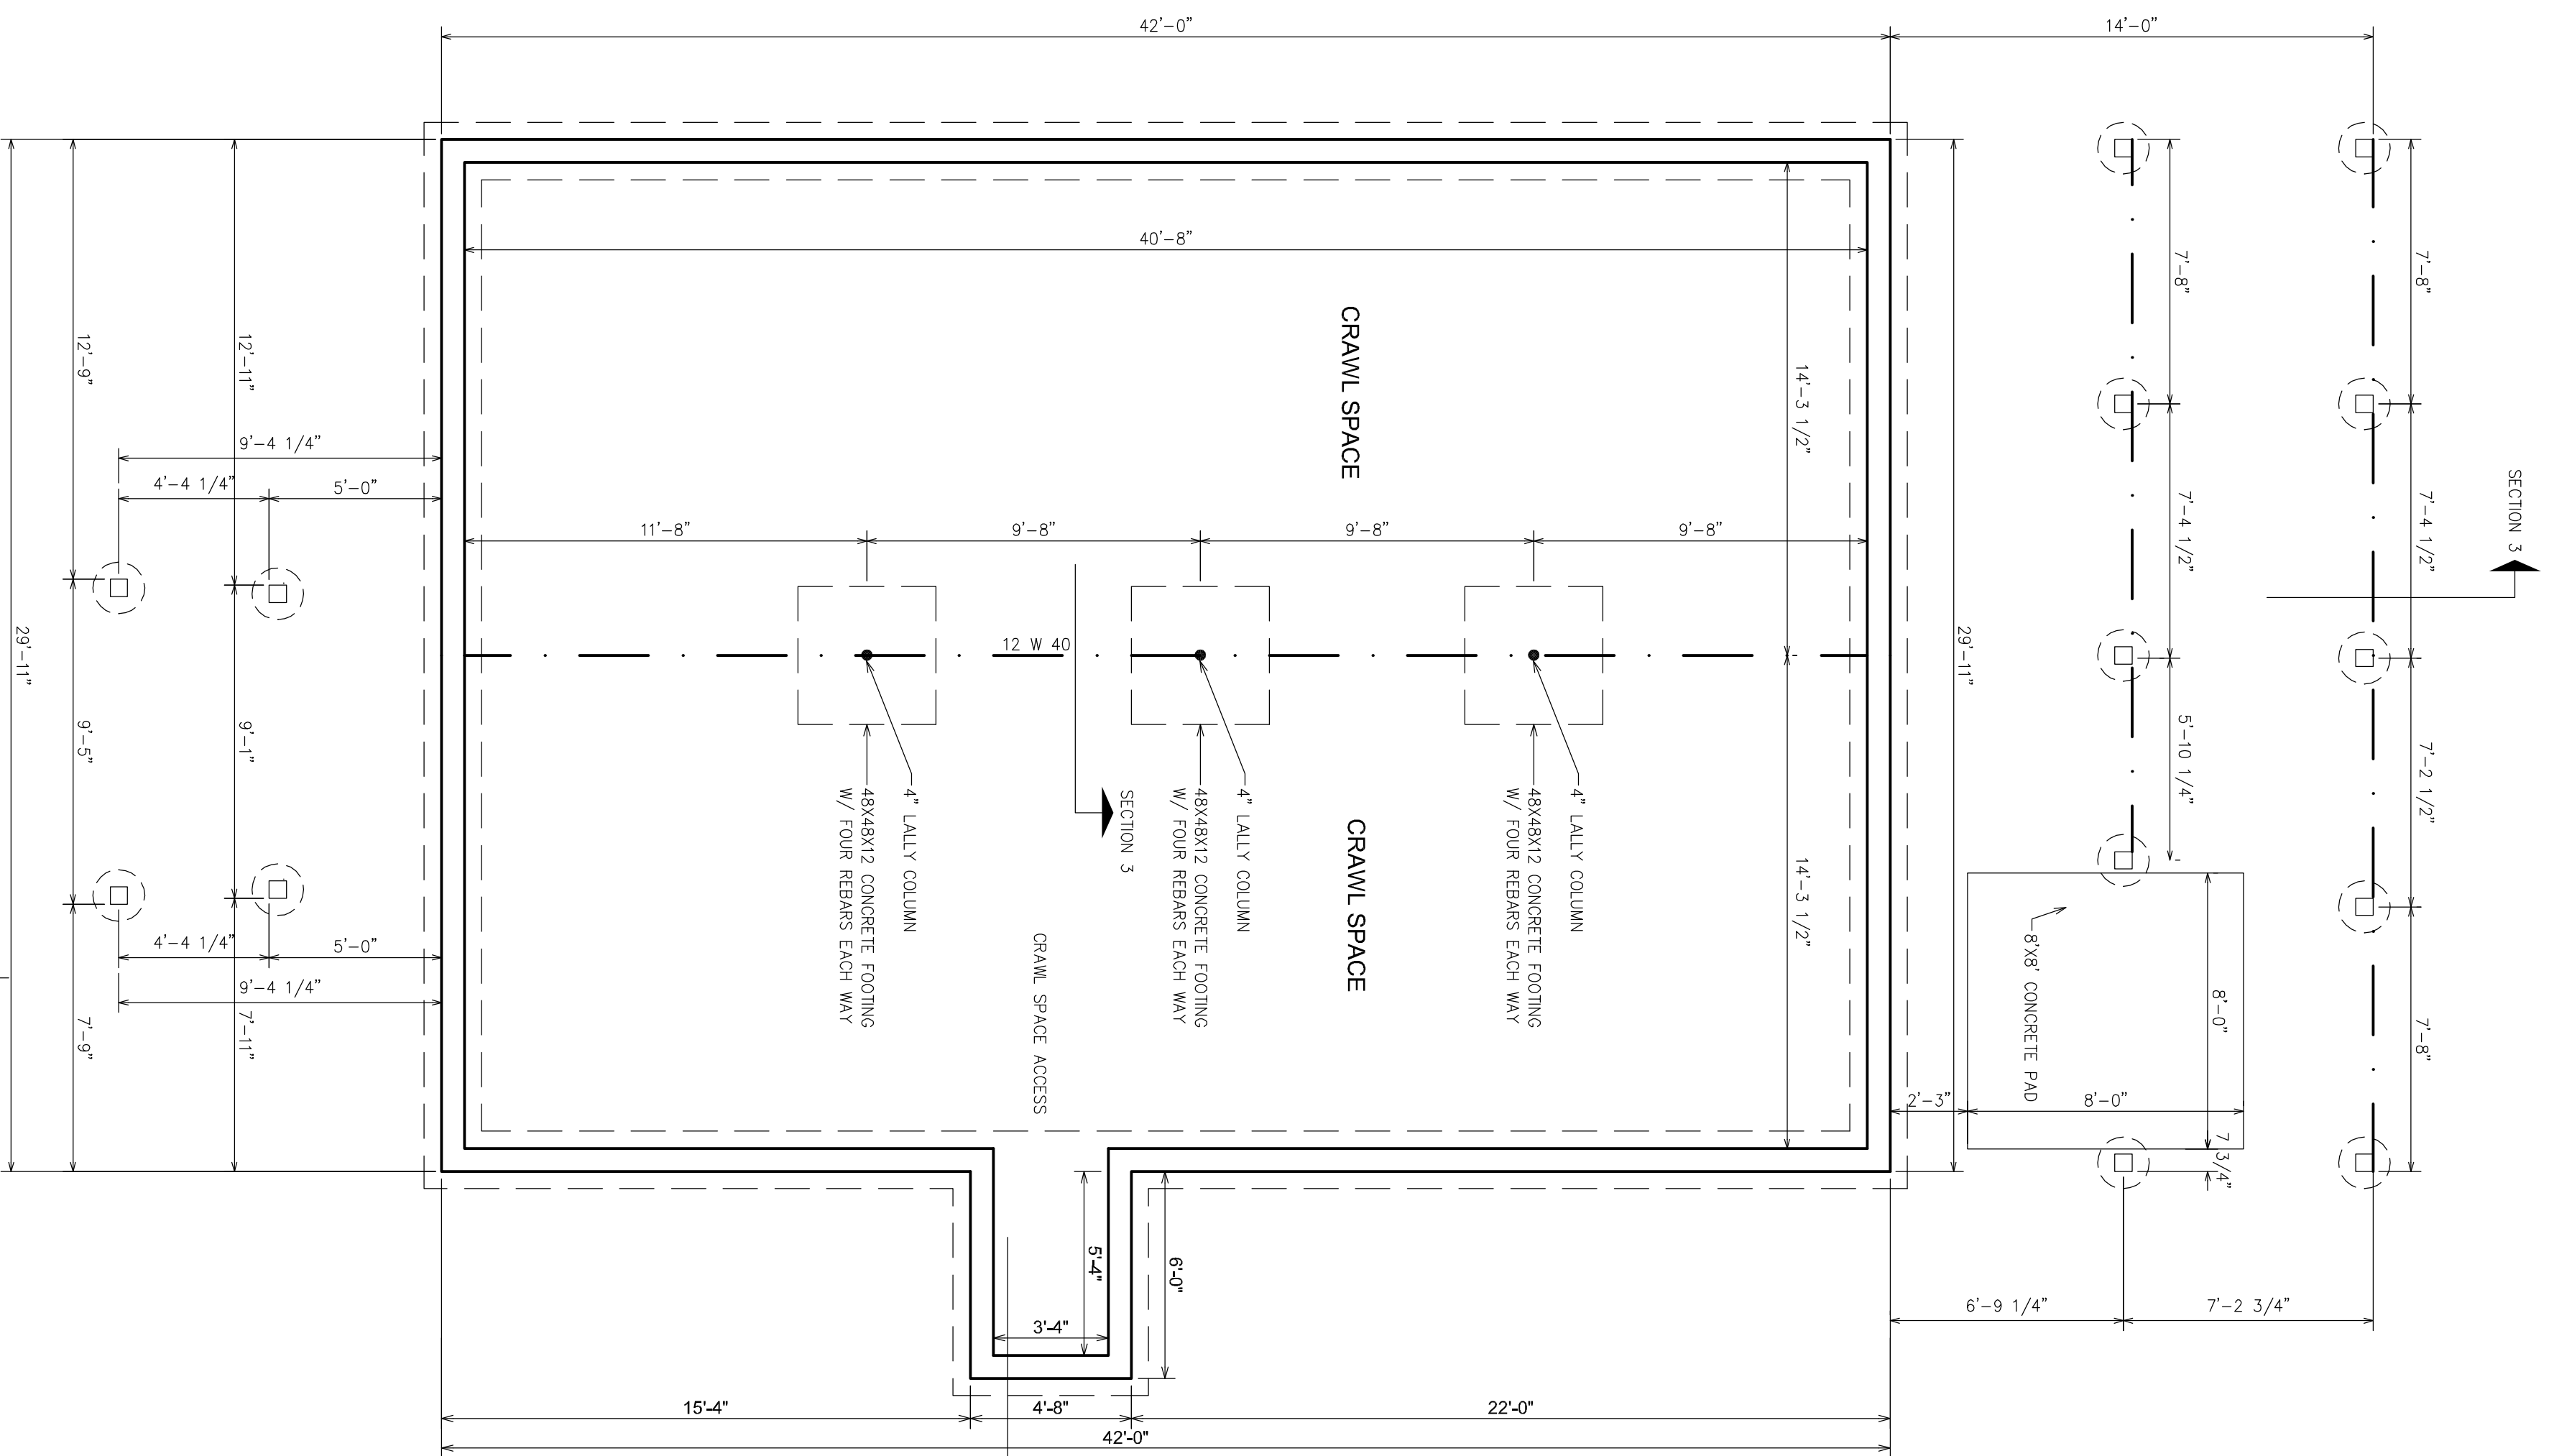

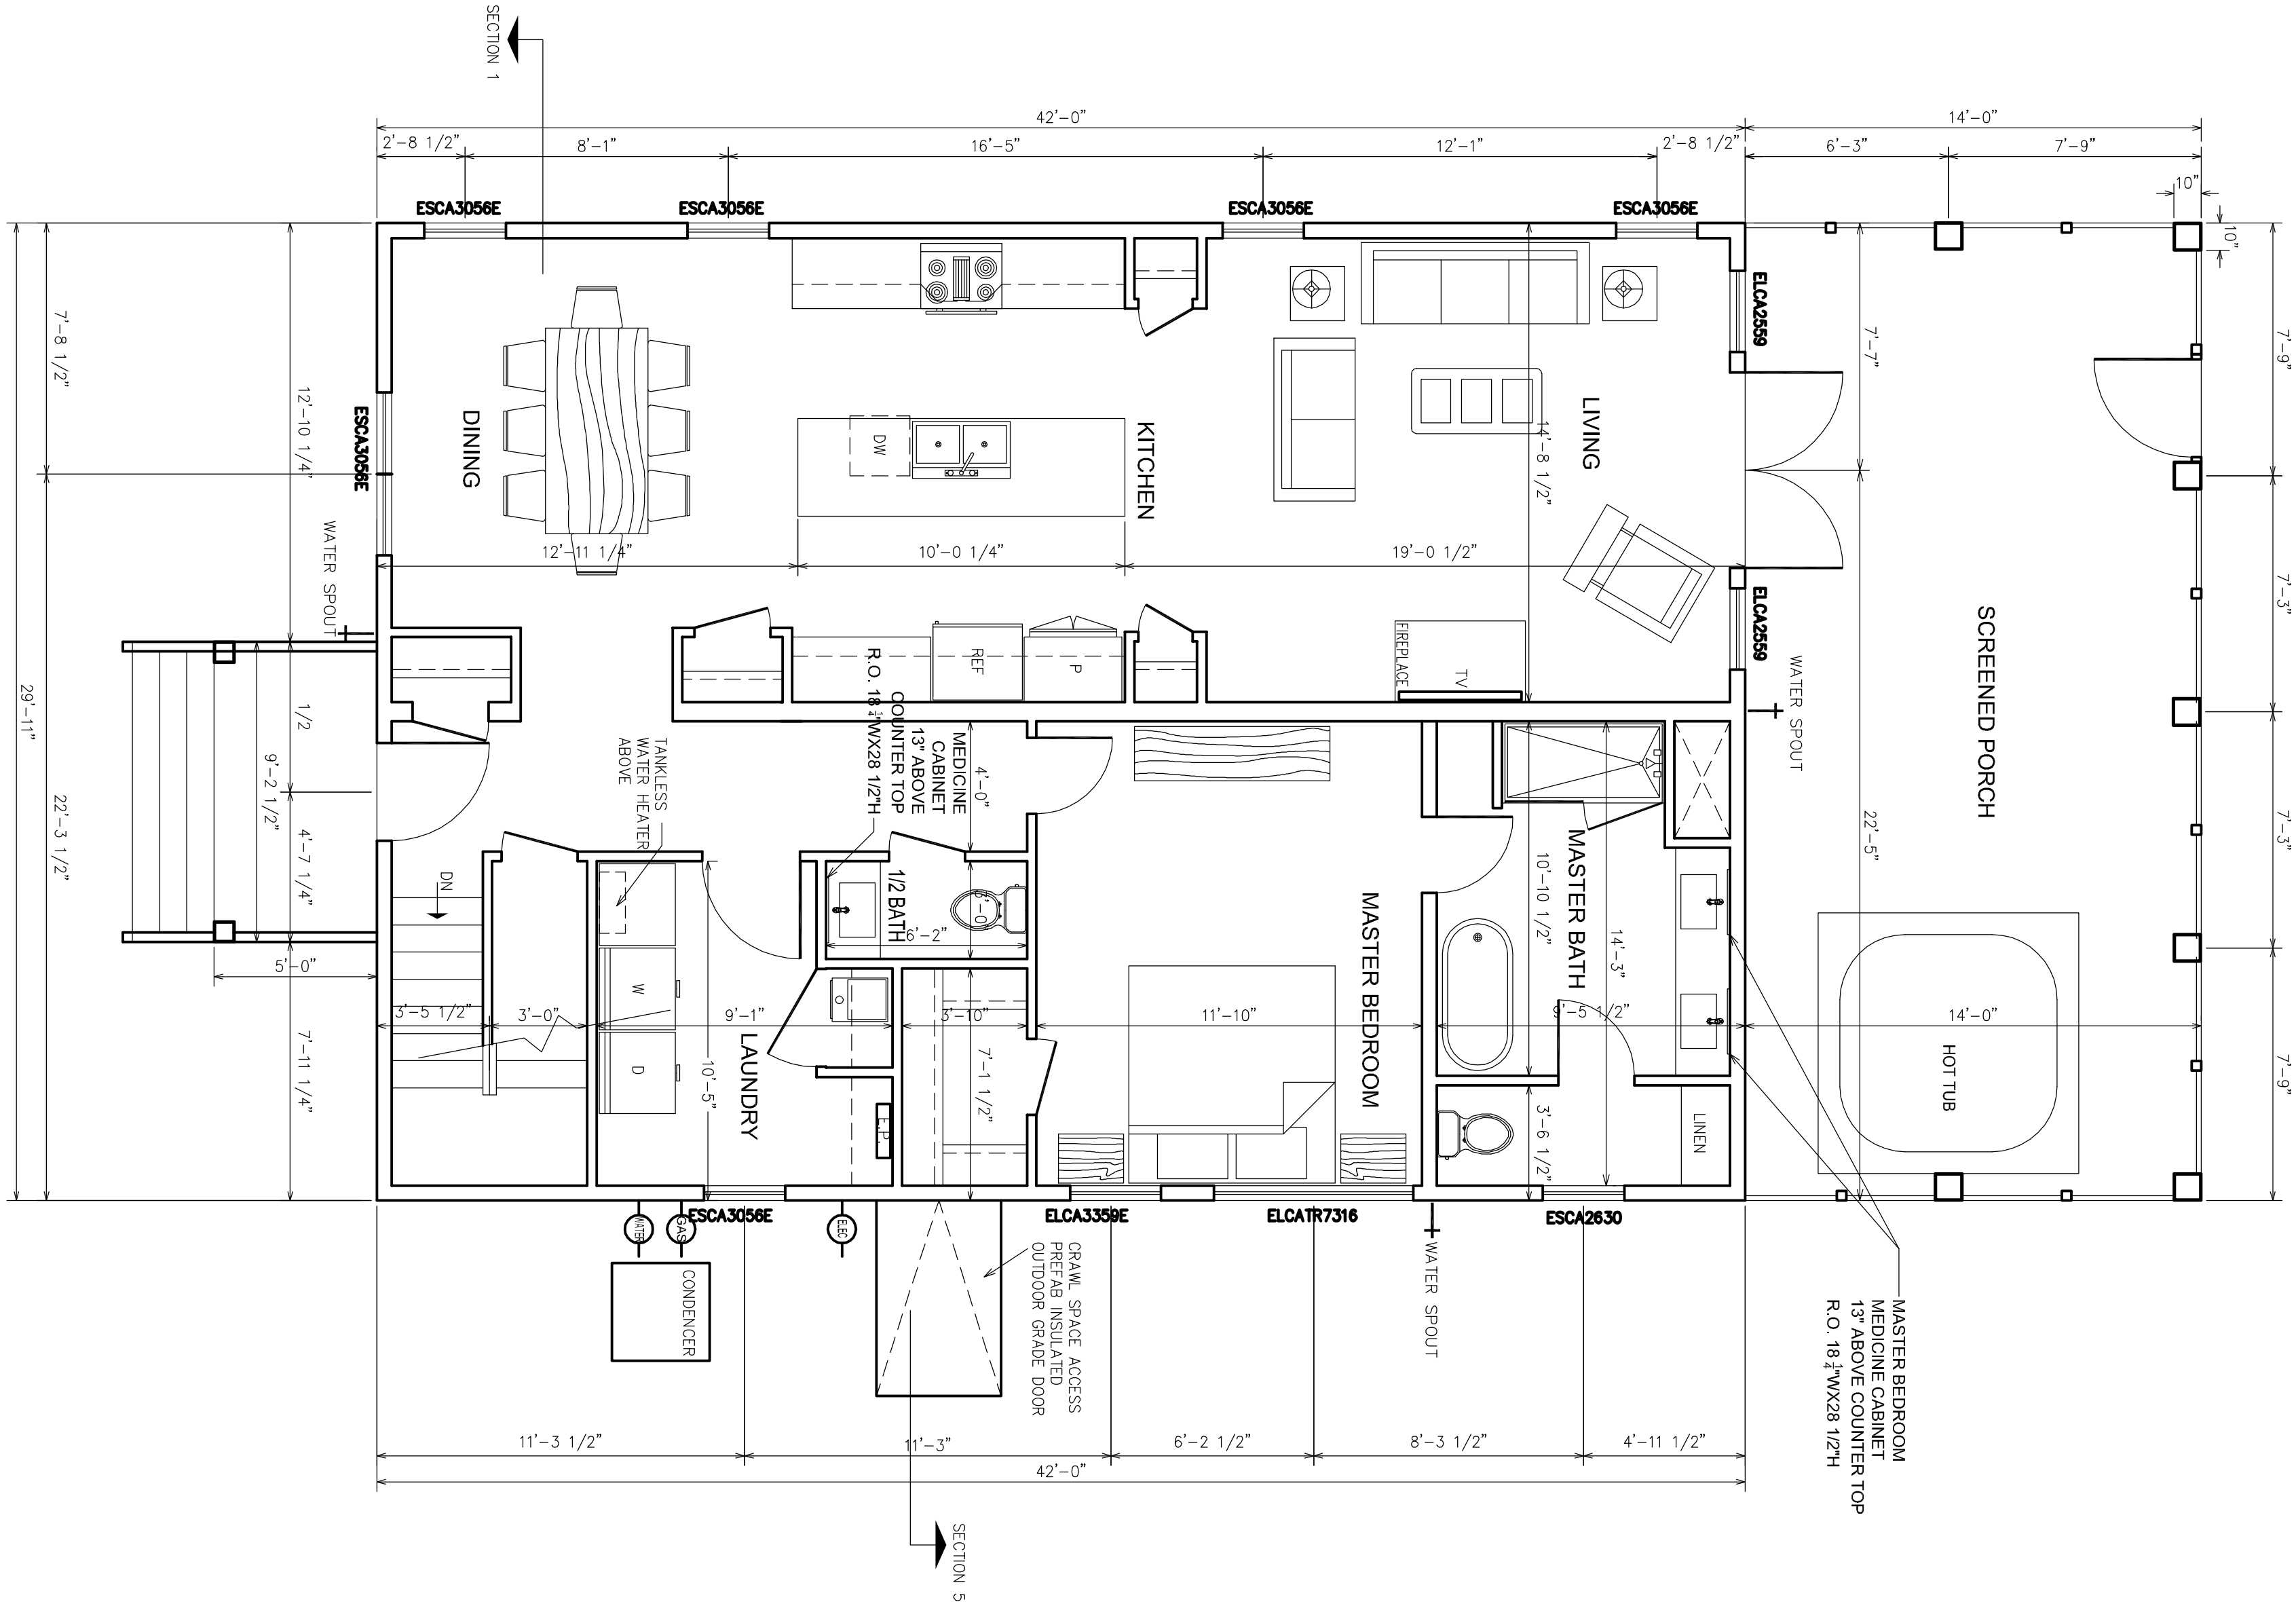

FIRST FLOOR PLAN


SCALE 1/4"=1'-0"

NOTES

- 1- ALL WINDOWS ARE CASMENT WINDOWS U. O. N.
- ASSEMBLED WINDOWS EXCESS MINIMUM OPENING HEIGHT 24"
- MINIMUM NET CLEARANCE OPENING 5.7 SQ FT
- MAXIMUM SILL HEIGHT NO MORE THAN 44" ABOVE FLOOR

SYMBOLS


- GAS METER
- WATER METER
- ELECTRIC METER

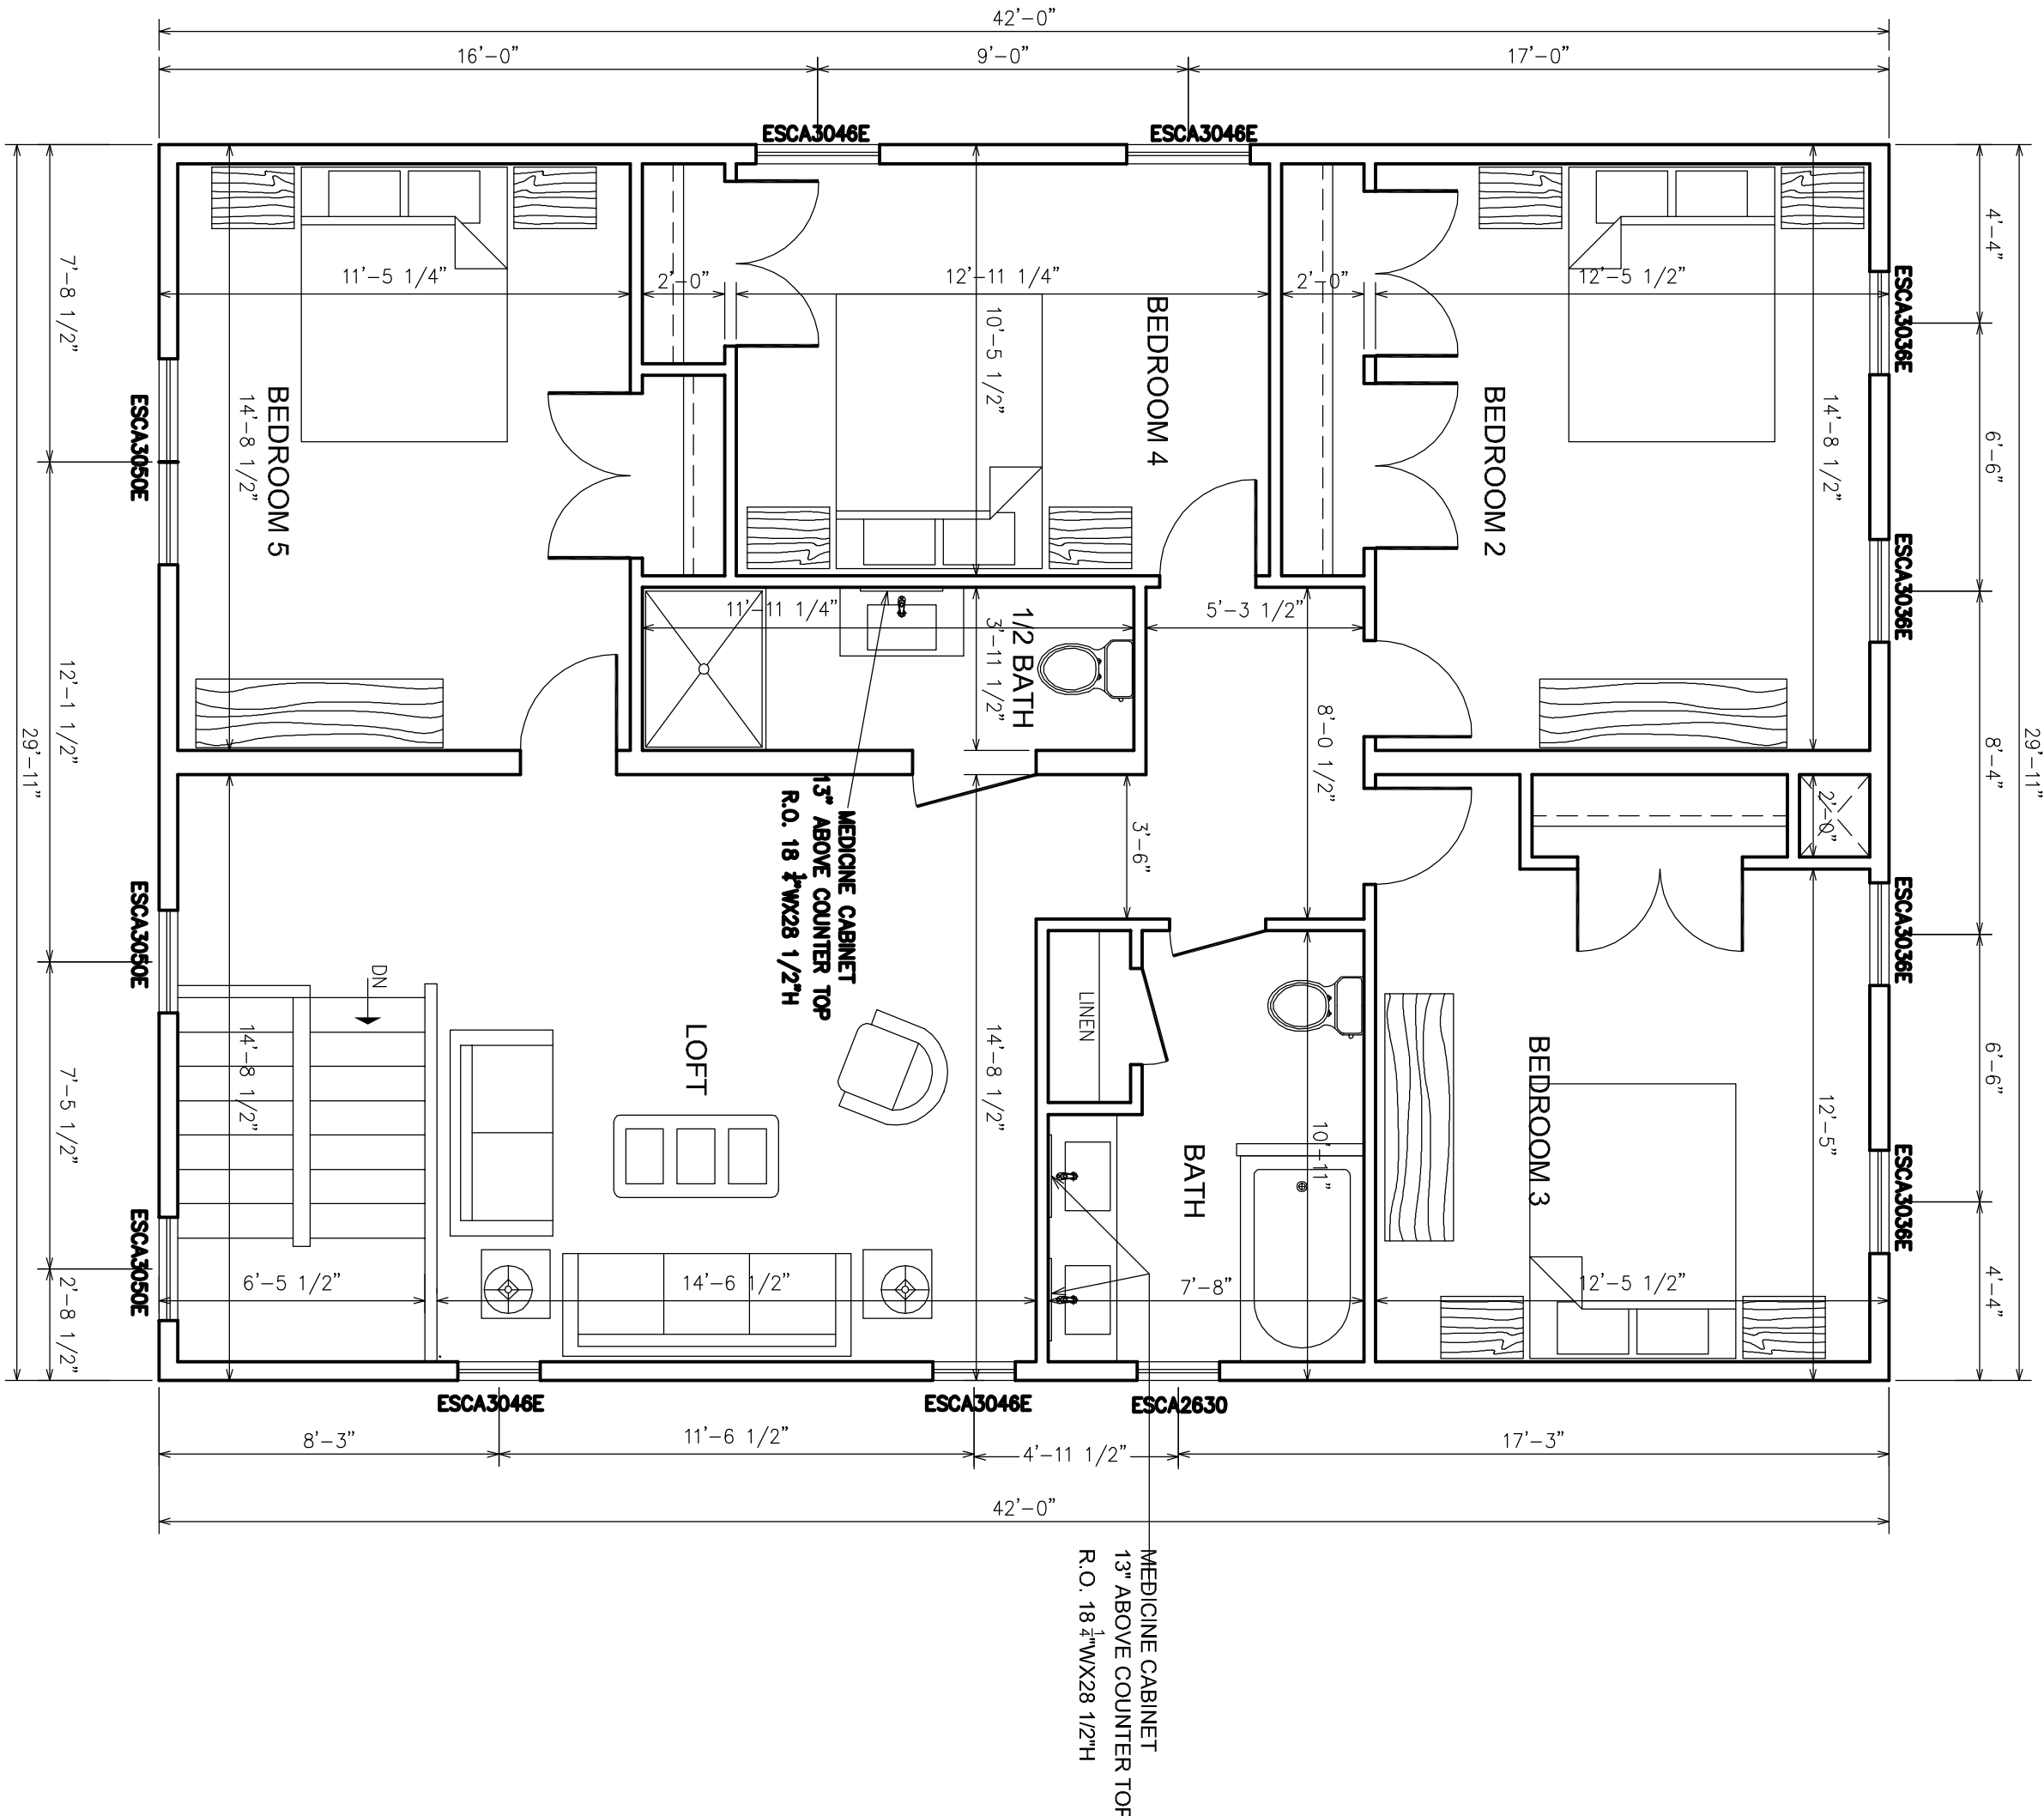

SECOND FLOOR PLAN


SCALE 1/4"=1'-0"

KENNETH MUNGUIA ARELLANO			
ARCHITECT			
5610 WULBERT AVENUE, PORTAGE IN 46368 (219) 763 6794			
PROJECT TITLE			
ARIES MODEL			
LOT 185 B JAKE LANE CASON PARK BEACHWOOD NEIGHBORHOOD, BEACHWALK MICHIGAN CITY INDIANA 46360			
SCALE		DRAWN	
1/4"=1'-0"		KIMA	
DATE		FIRST FLOOR PLAN	
NOV/16/2023		SECOND FLOOR PLAN	
			SHEET
			4

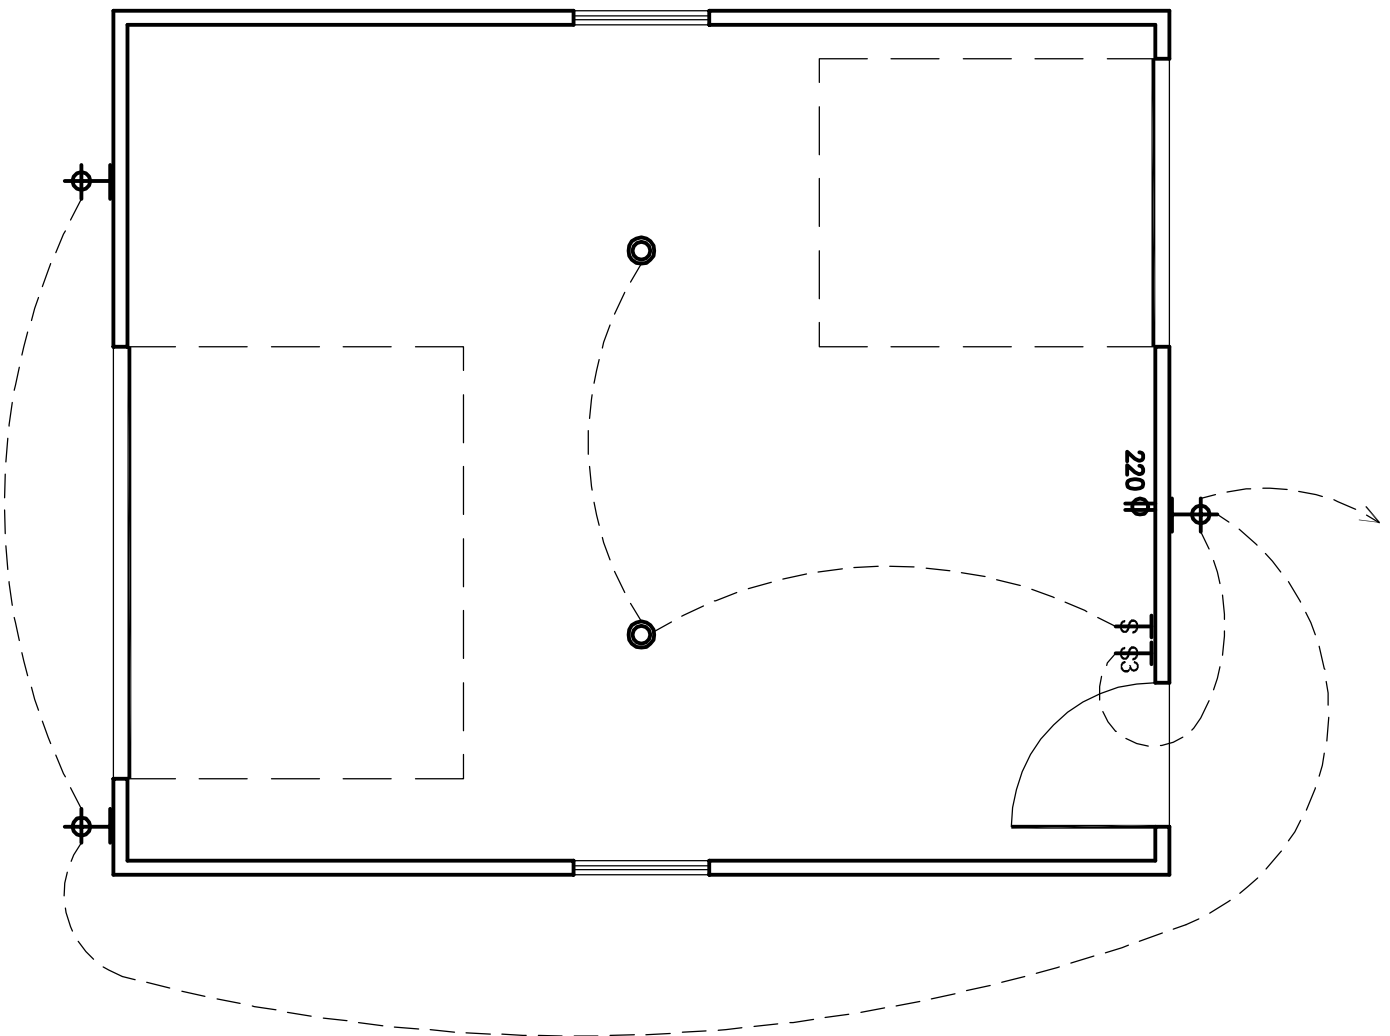



GARAGE ELECTRICAL PLAN

SCALE 1/4"=1'-0"

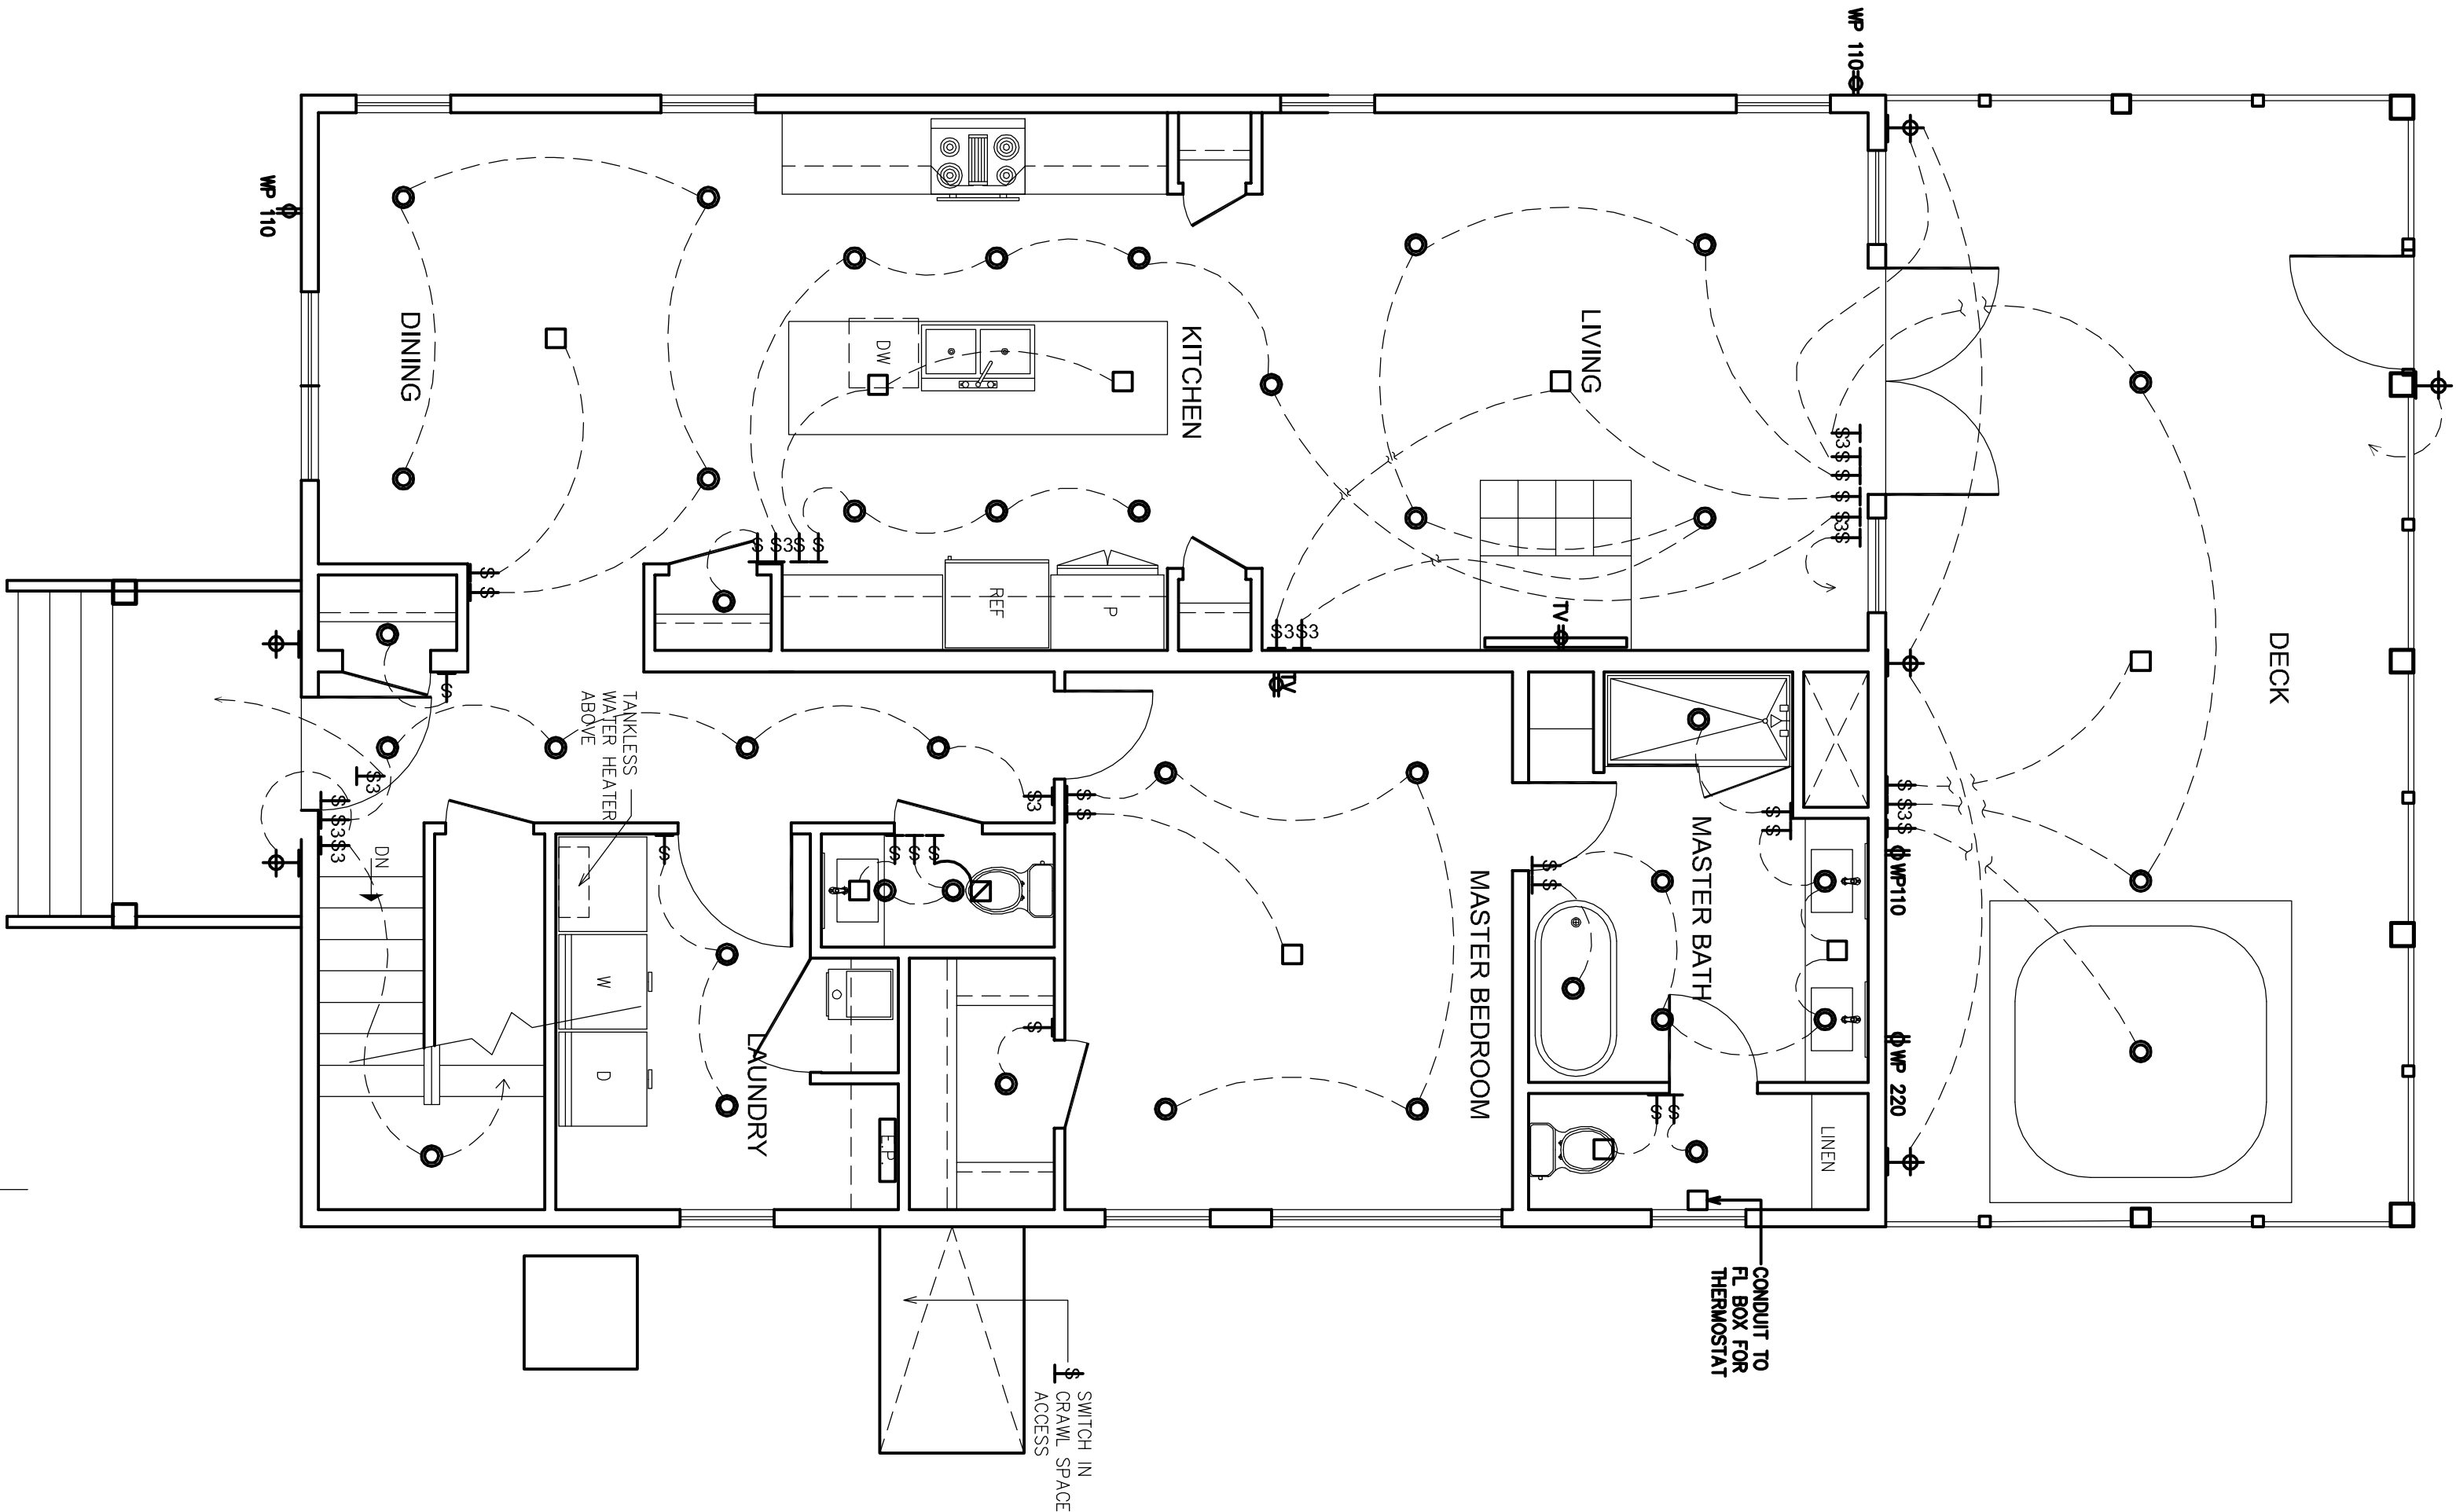


ELECTRICAL 1ST FLOOR PLAN

SCALE 1/4"=1'-0"

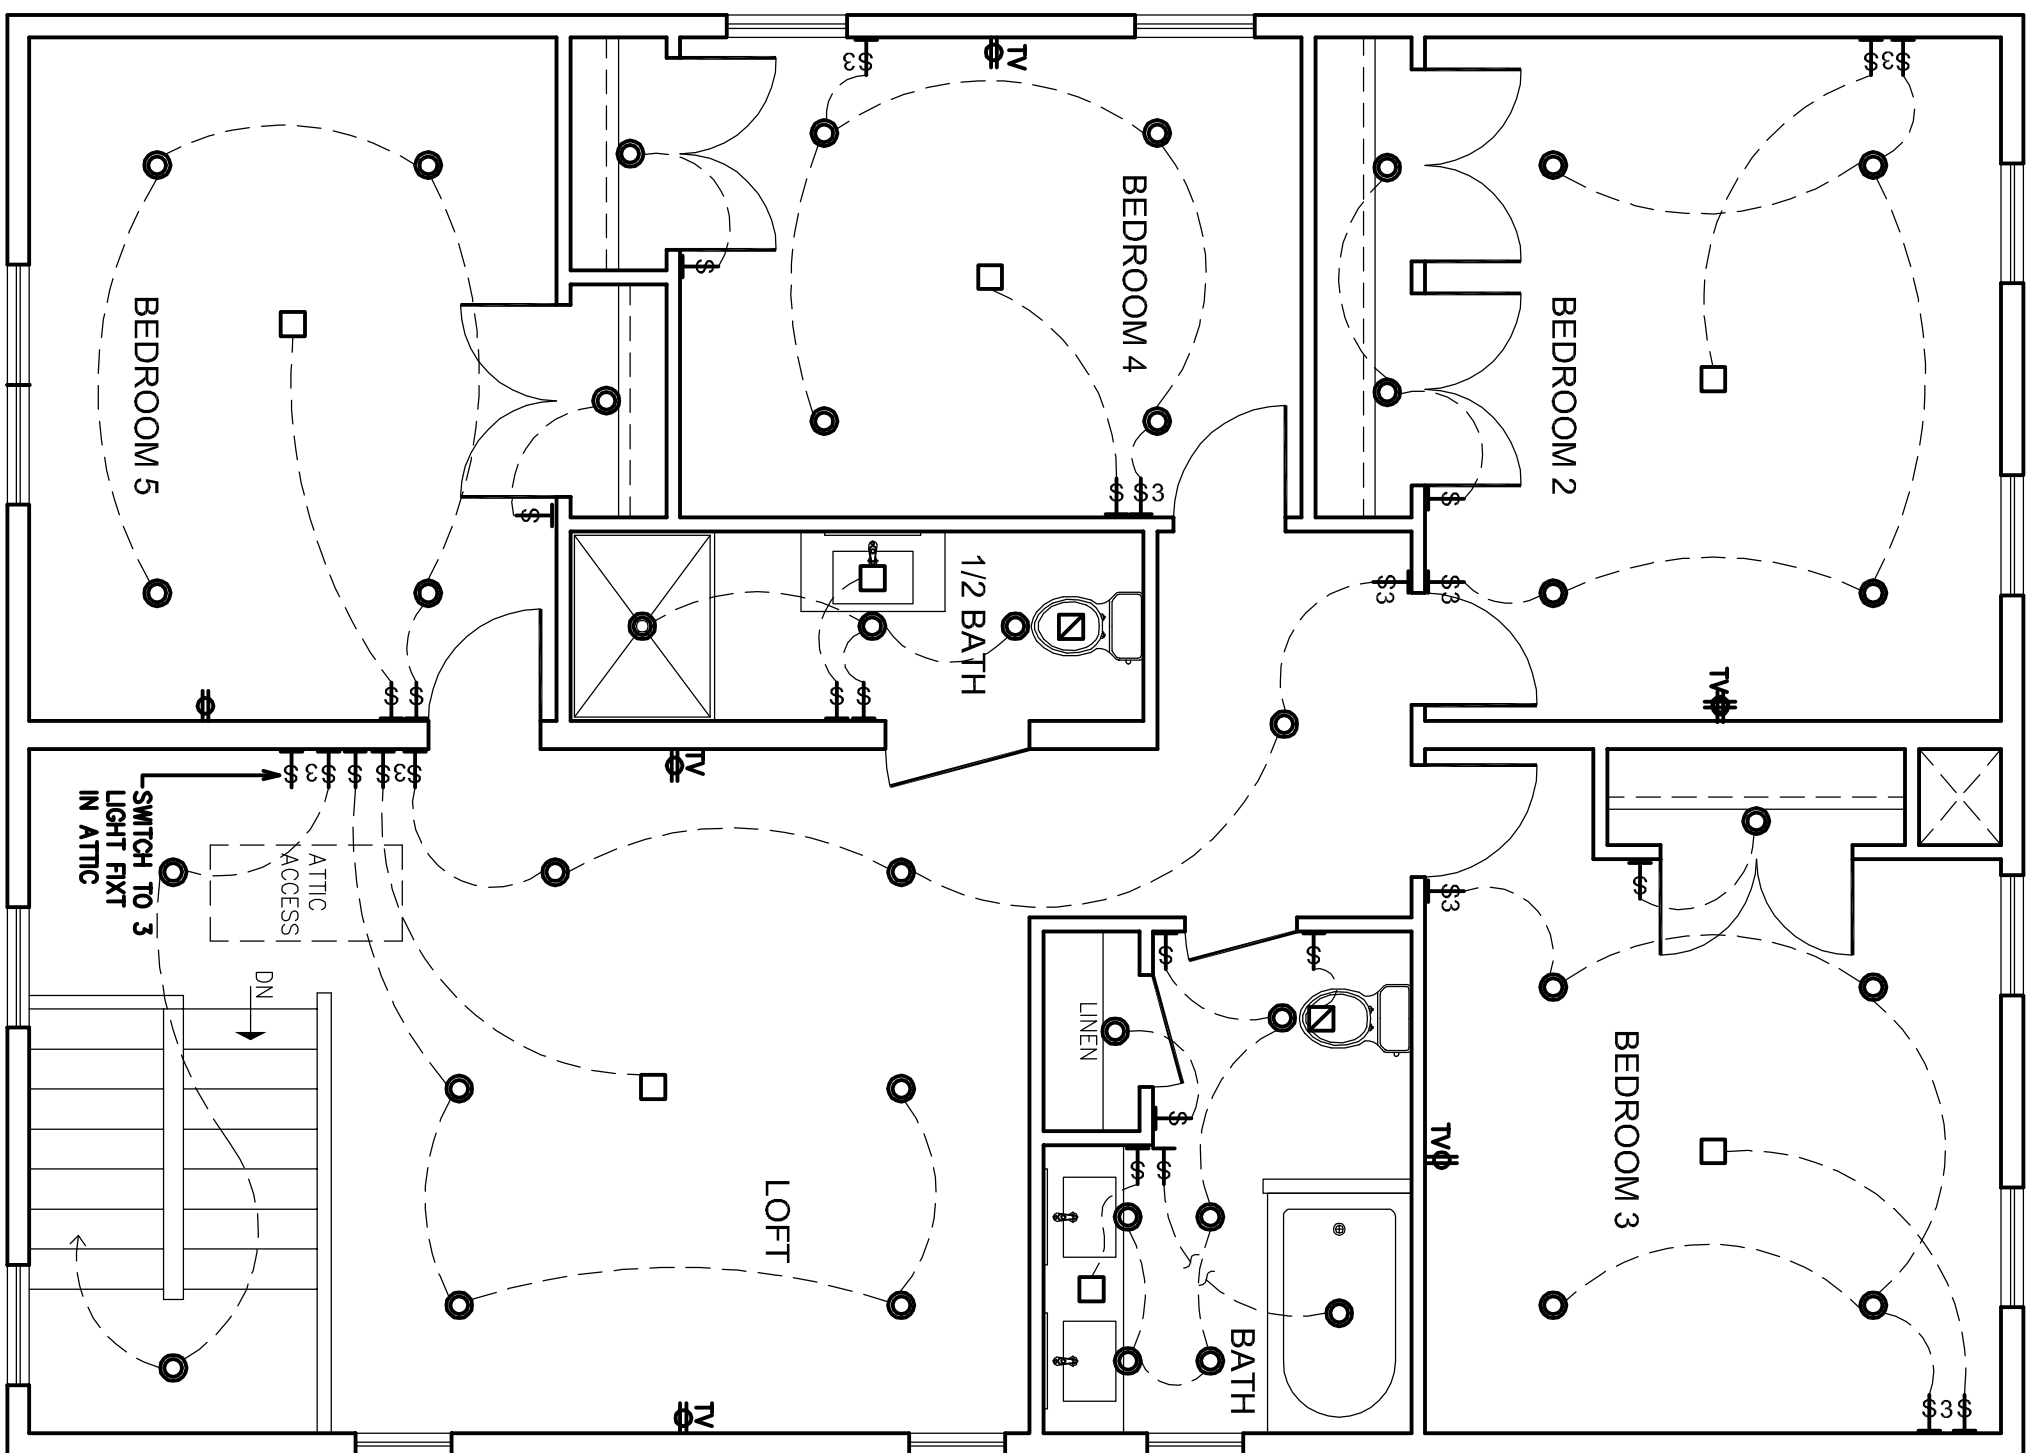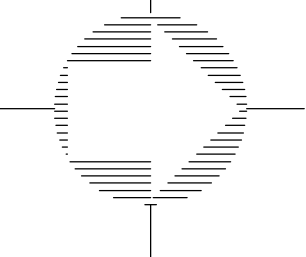

ELECTRICAL 2ND FLOOR PLAN


SCALE 1/4"=1'-0"

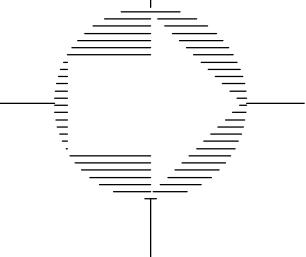


SYMBOLS

- CEILING MOUNTED LIGHT FIXTURE
- WALL MOUNTED LIGHT FIXTURE (SCONCE)
- JUNCTION BOX
- SWITCH
- TWO WAY SWITCH
- EXHAUST FAN
- WP220 220 WATER PROOF OUTLET
- WP110 110 WATER PROOF OUTLET
- TV 120V OUTLET


IRBA KENNETH MUNGUIA ARELLANO ARCHITECT			PROJECT TITLE	
LOT 185 B CASON PARK BEACHWOOD, NEIGHBORHOOD, BEACHWALK MICHIGAN CITY INDIANA 46360			ARIEL MODEL	
5610 WOLBERT AVENUE, PORTAGE IN 46368 (219) 763 6794			DRAWN	
SCALE 1/4"=1'-0"			KIMA	
DATE AUG./23/2023			PROPOSED LIGHTING 1ST FLOOR PLAN PROPOSED LIGHTING 2ND FLOOR PLAN	
			SHEET	
			5	

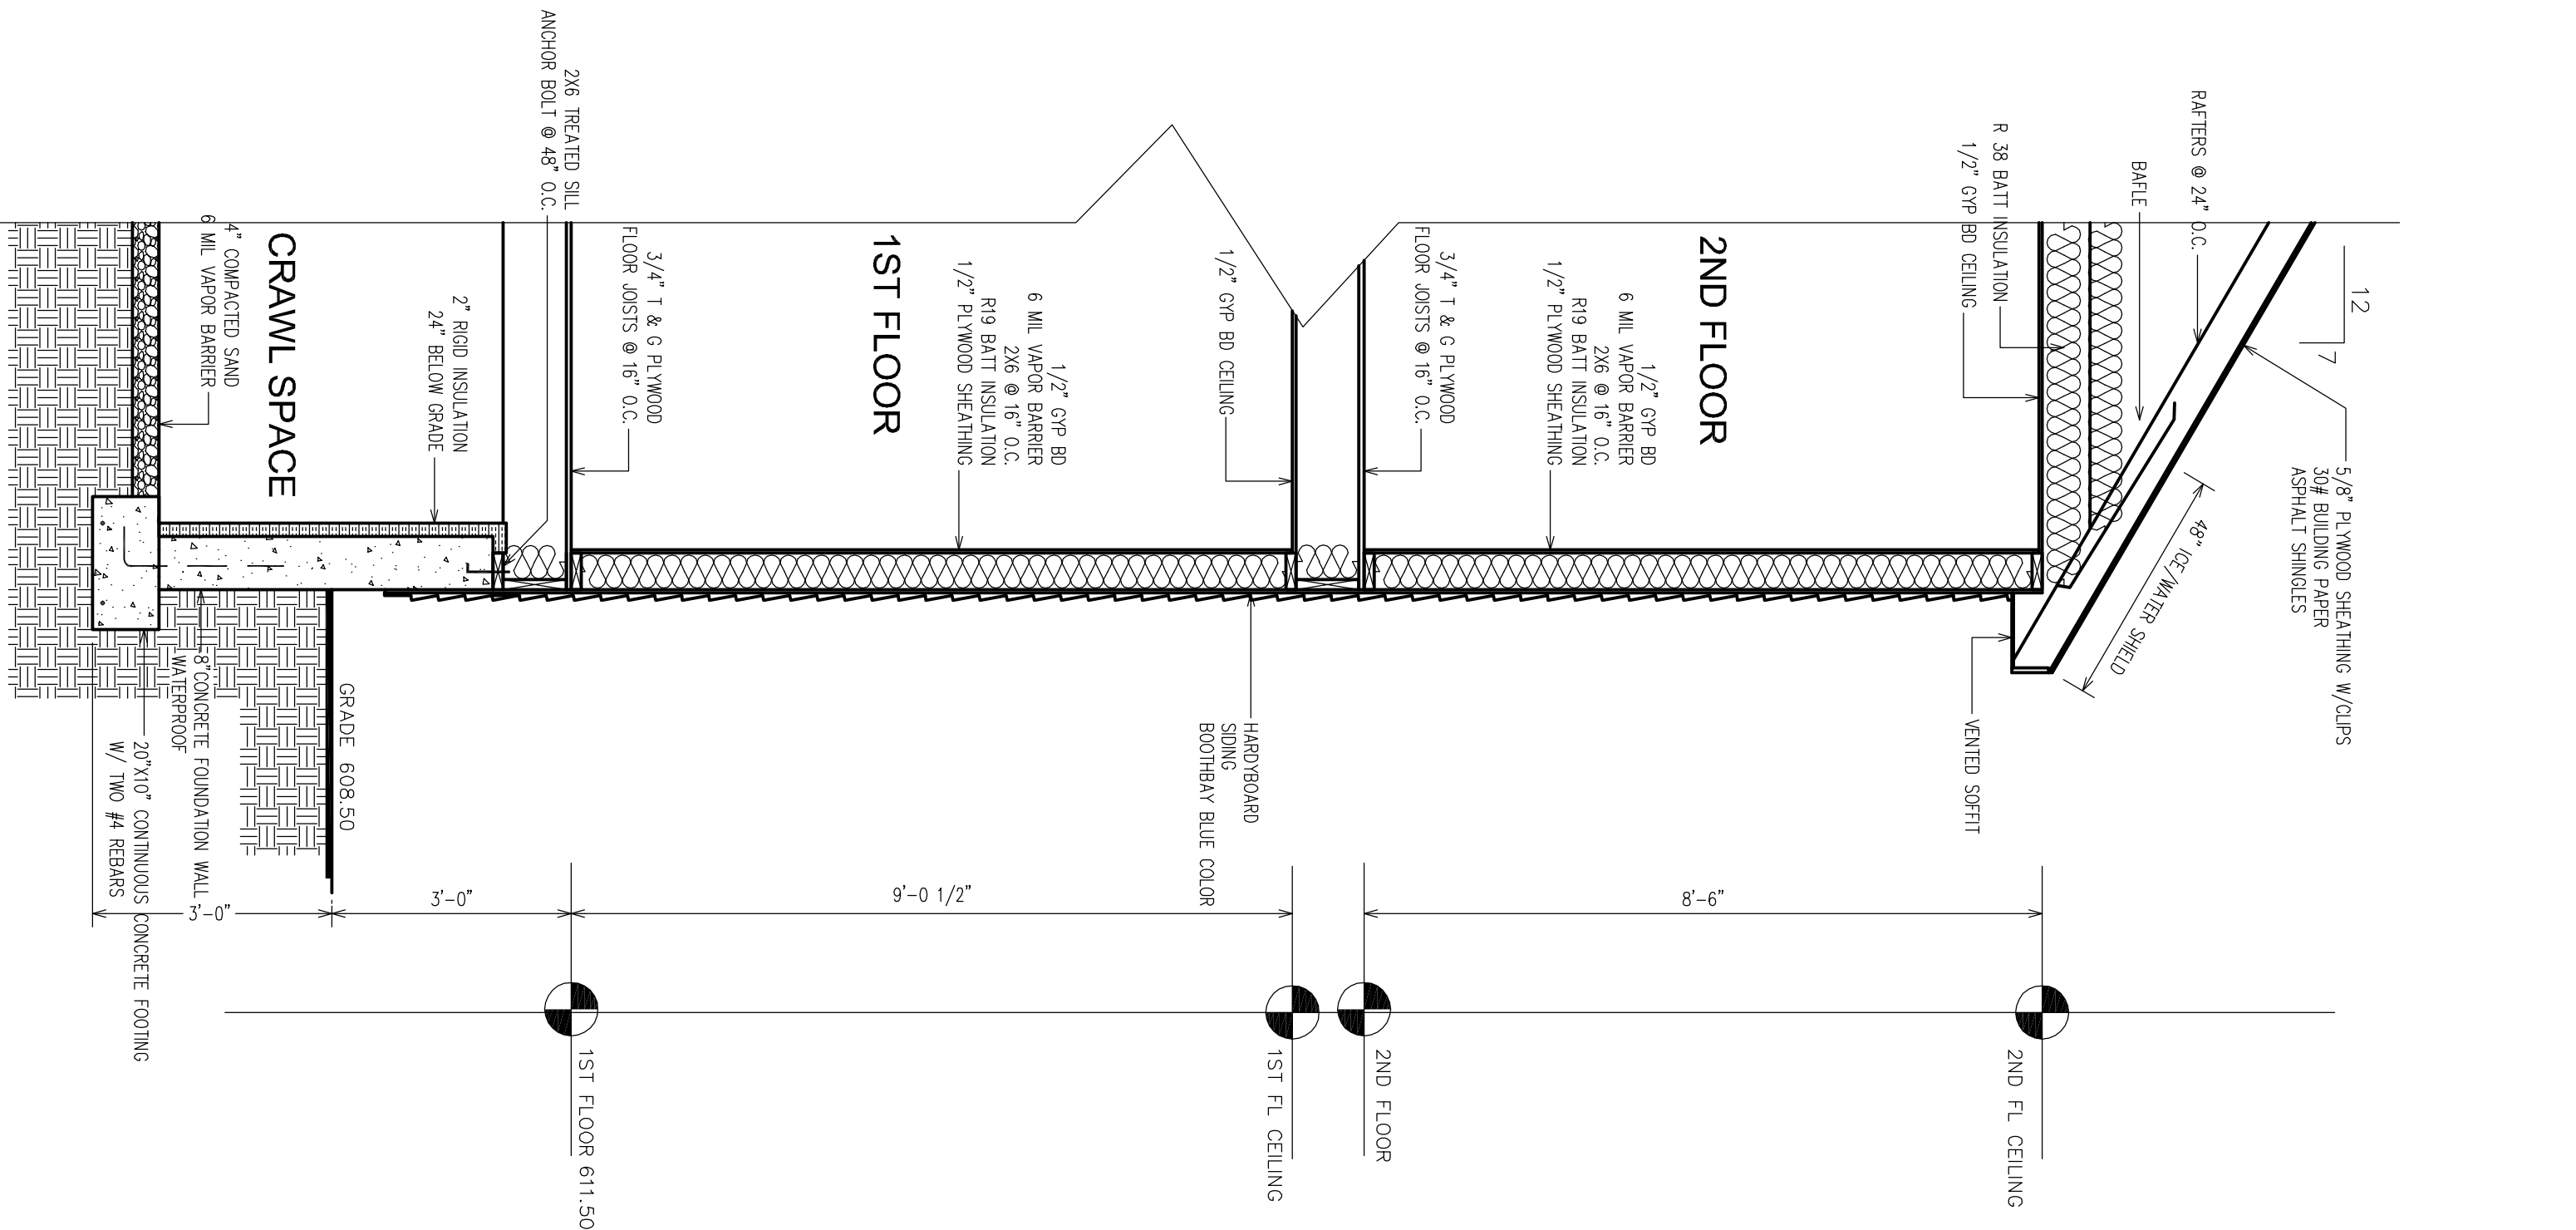

WALL SECTION 1
SCALE 1/2"=1'-0"

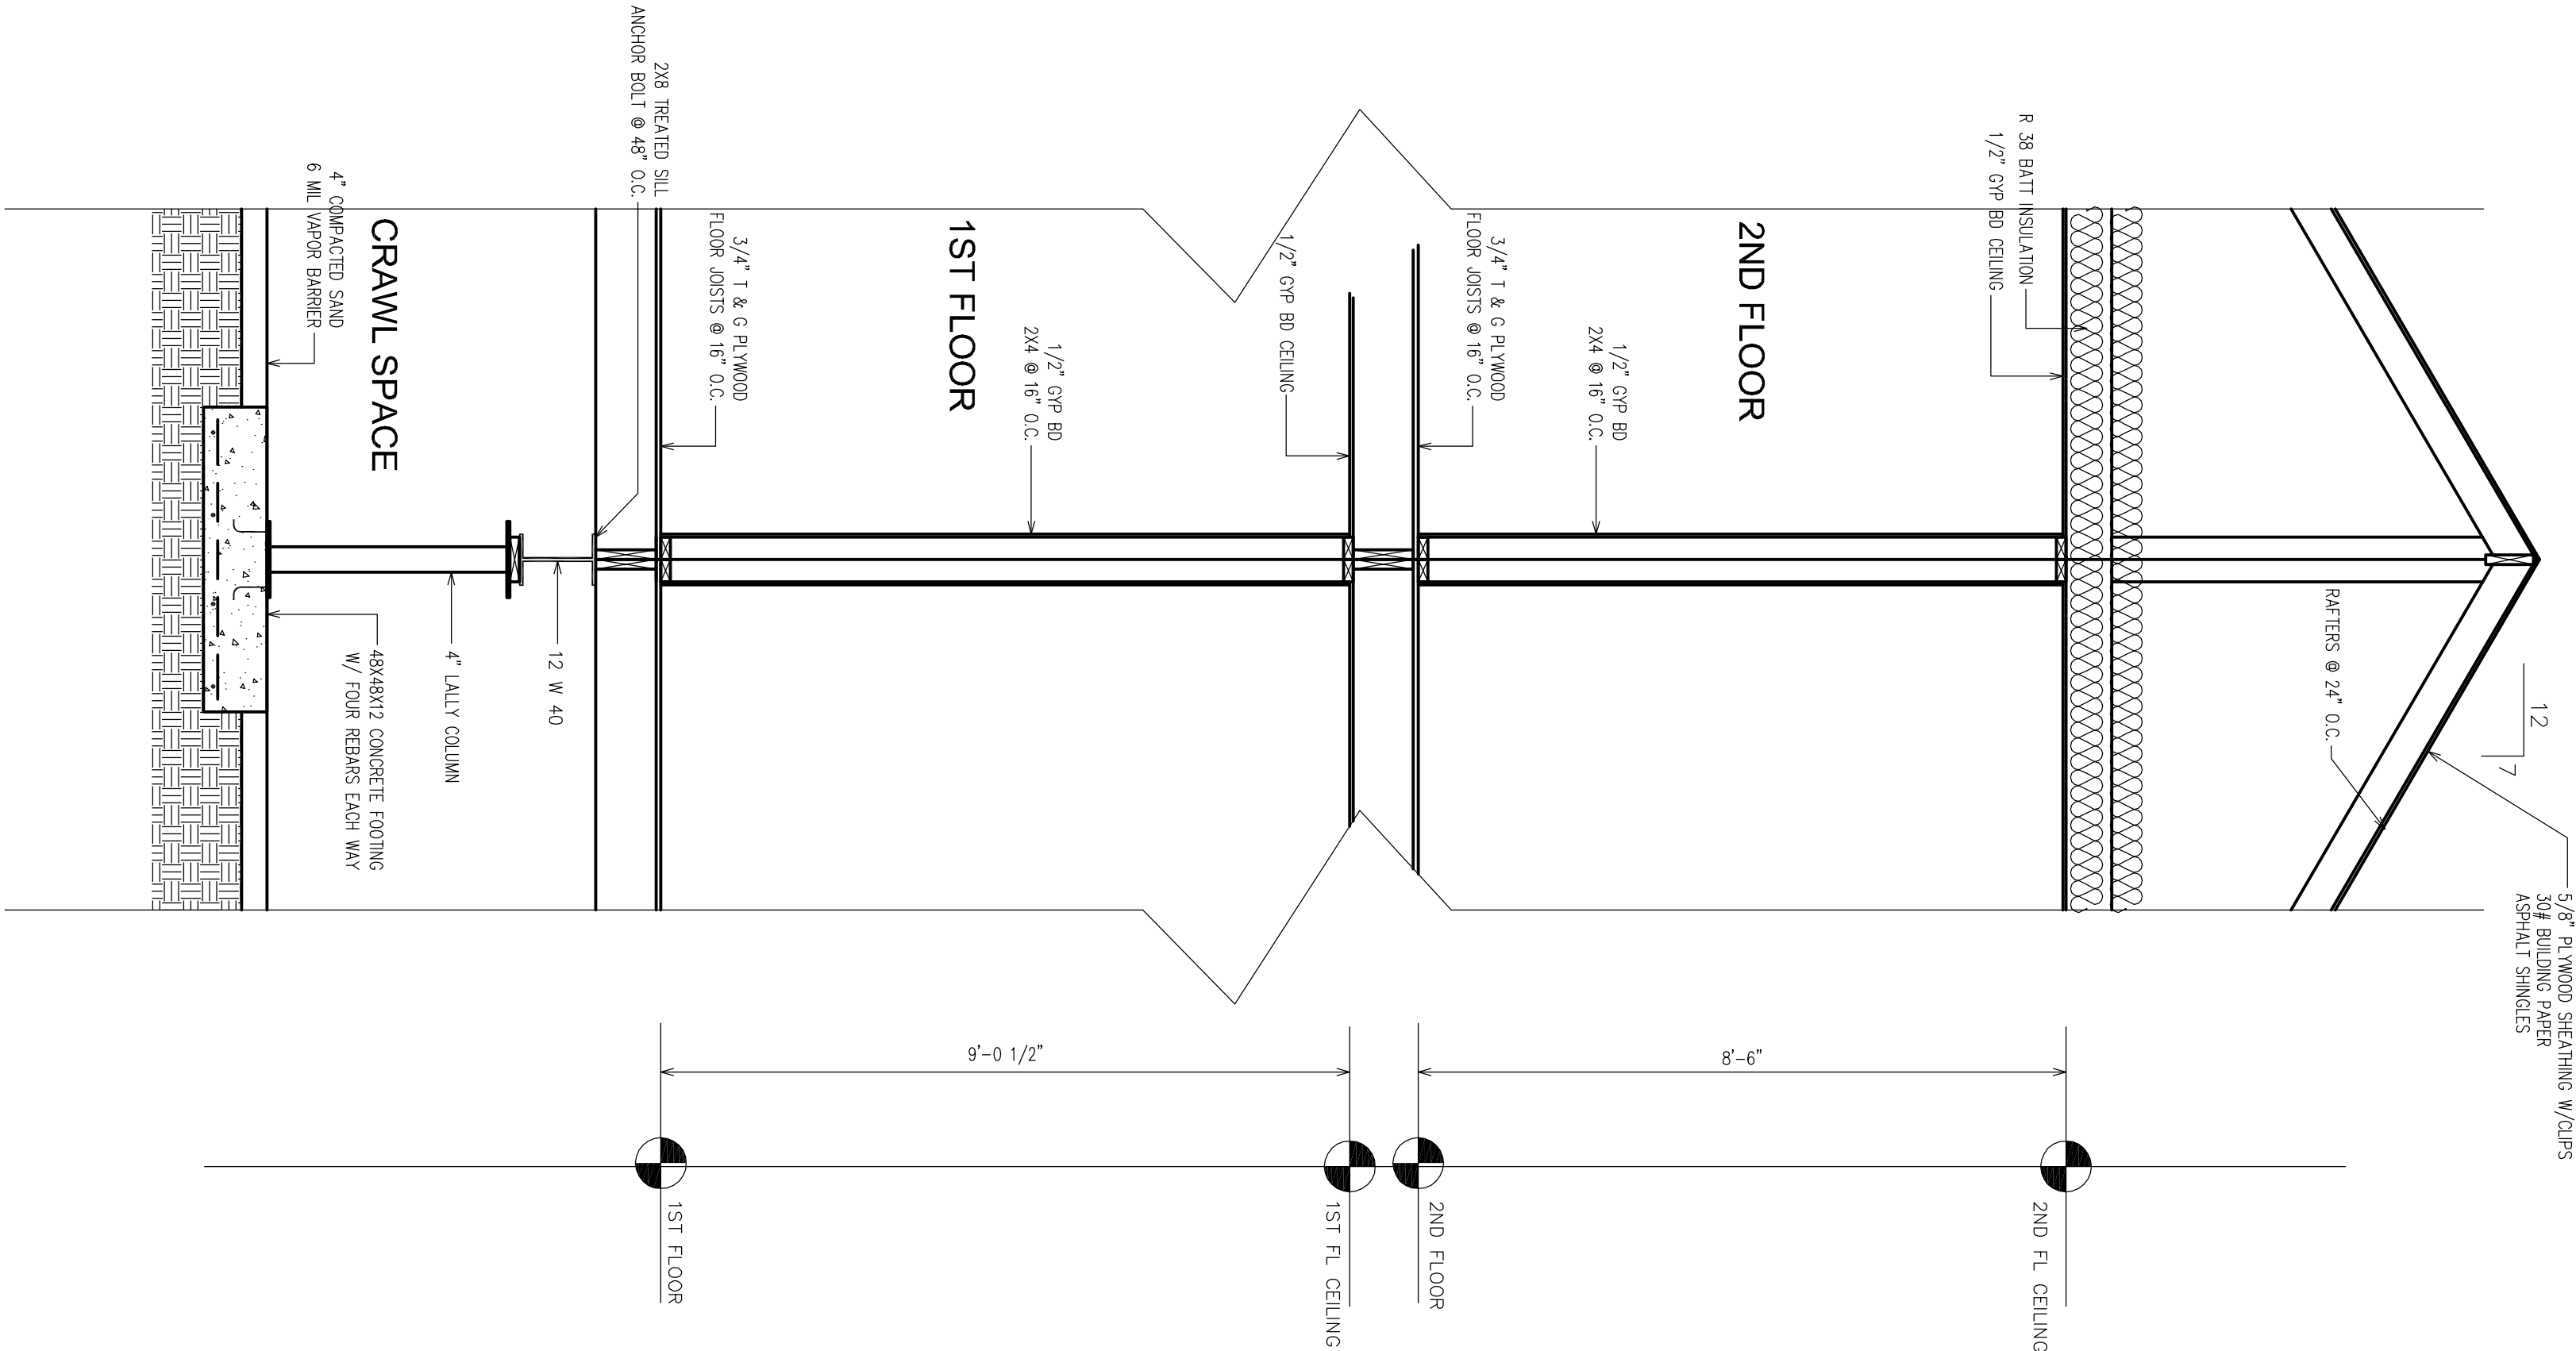

WALL SECTION 2
SCALE 1/2"=1'-0"

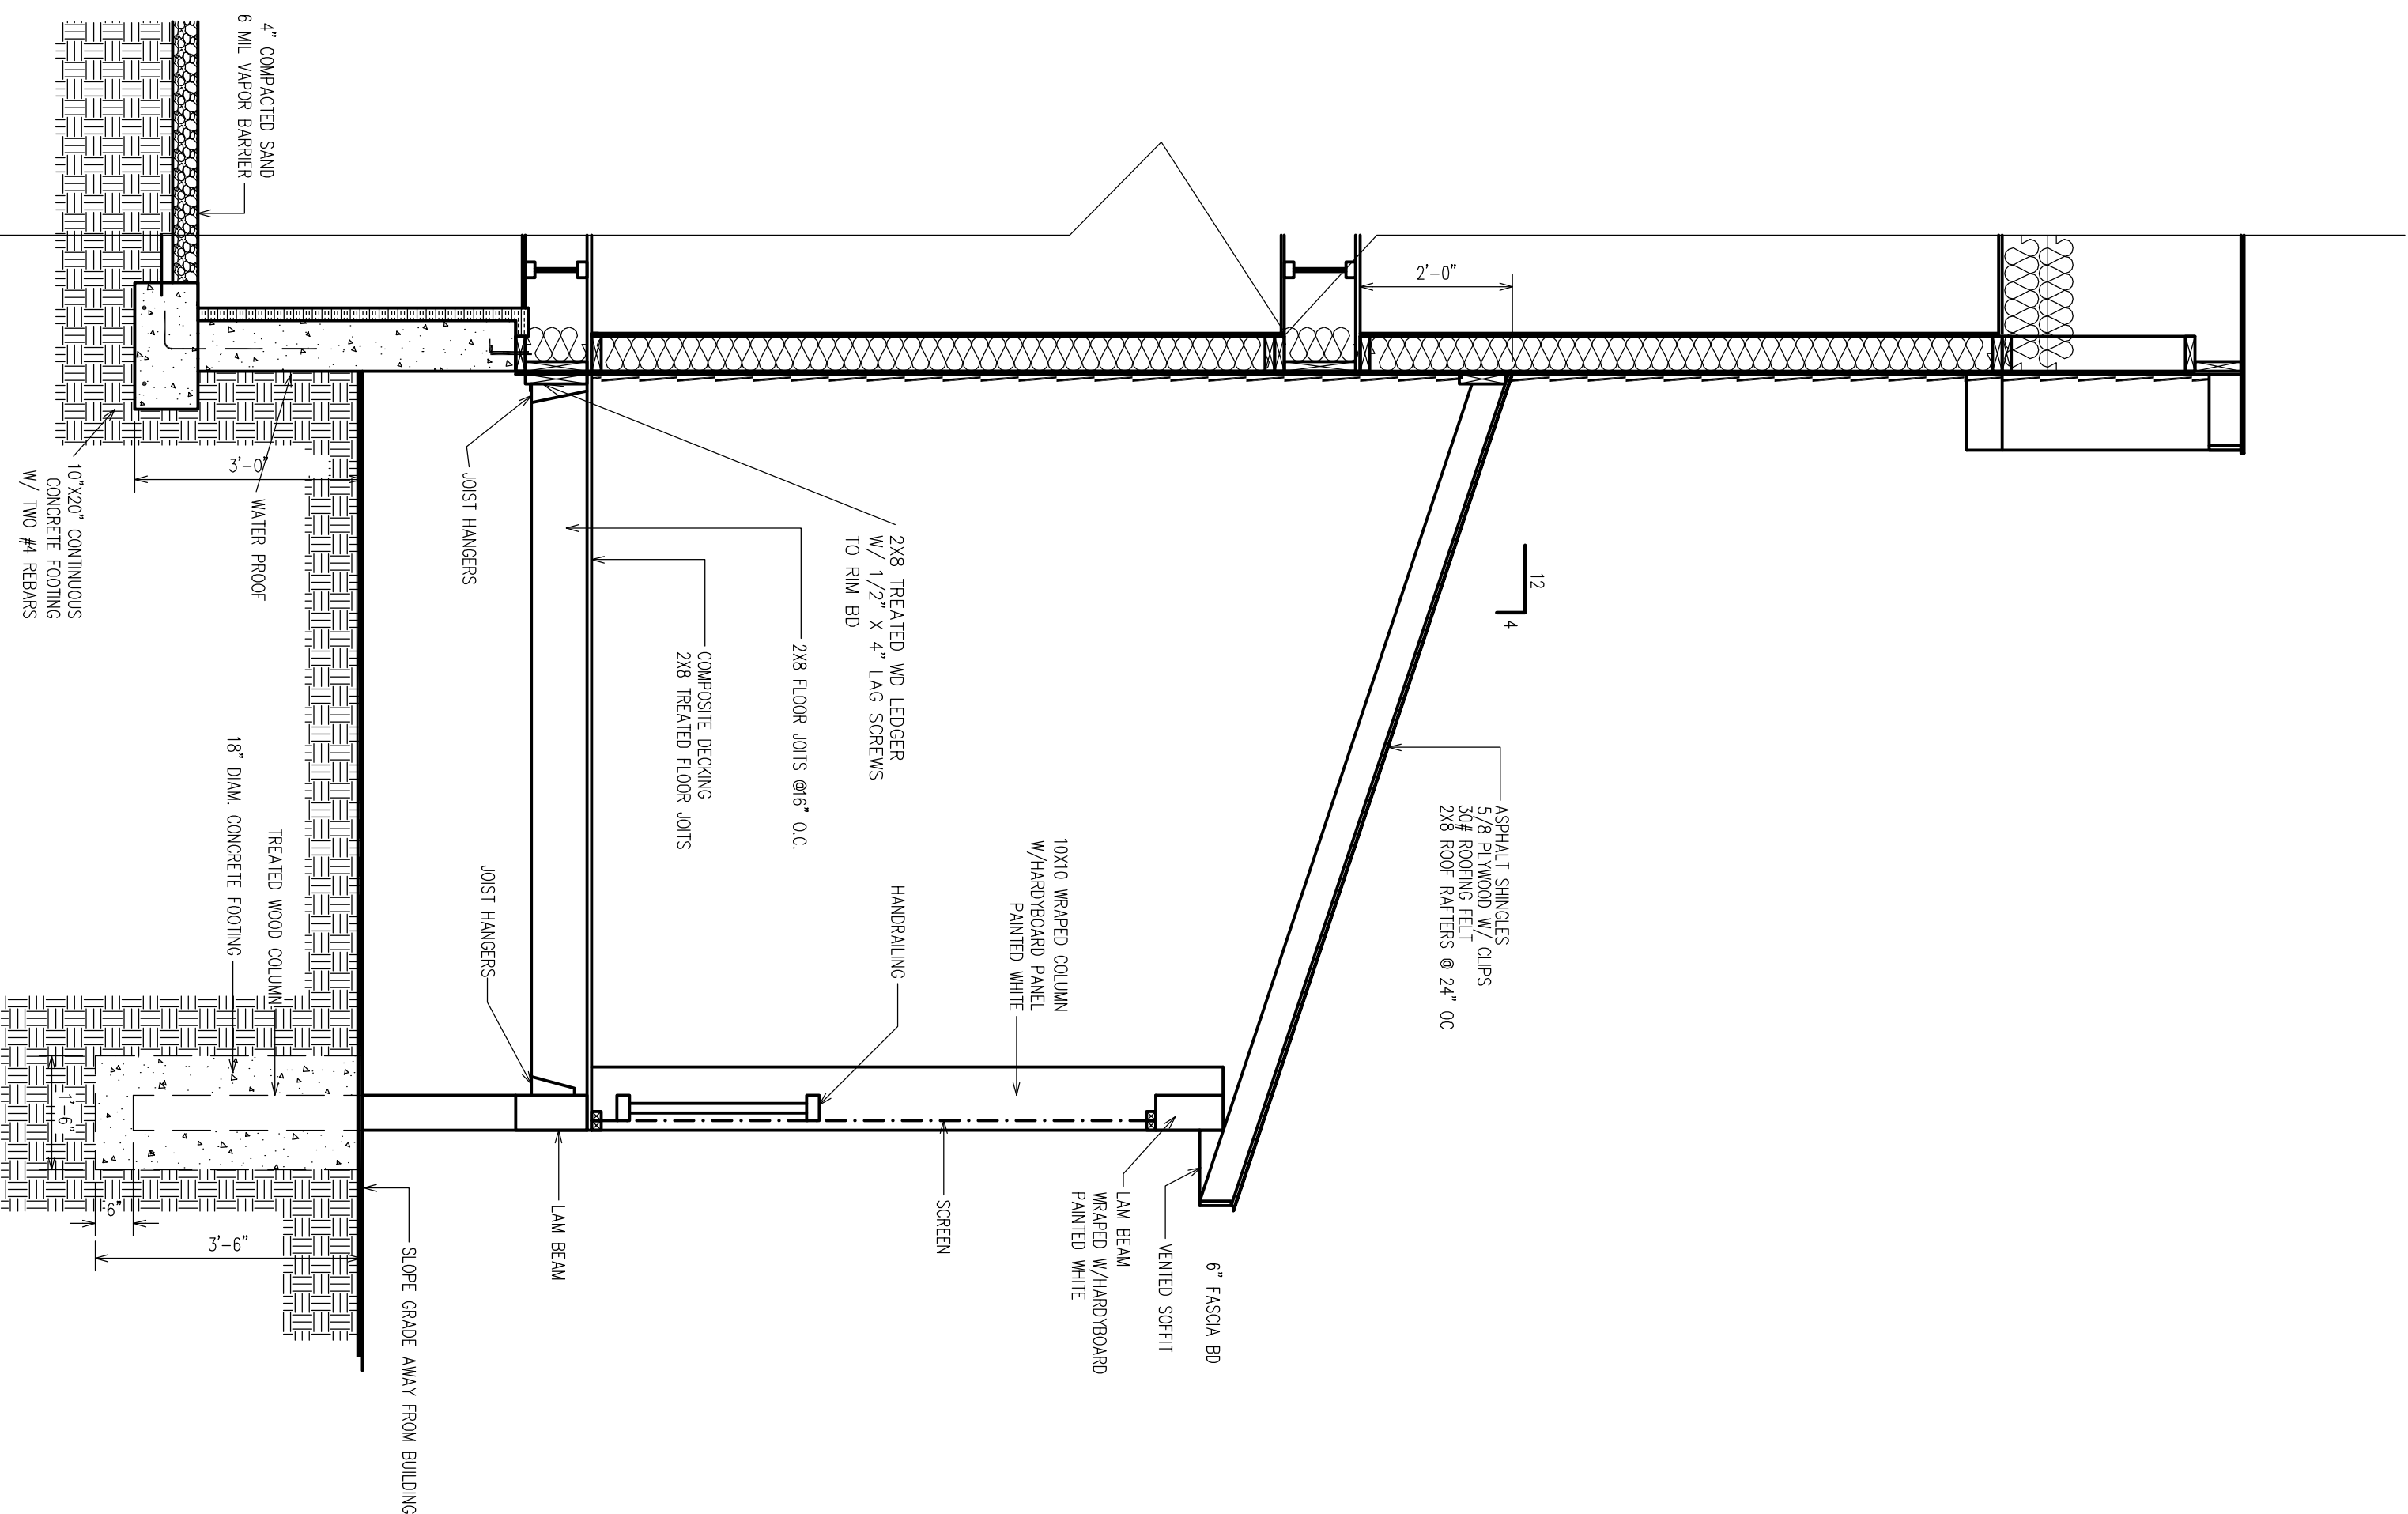

WALL SECTION 3
SCALE 1/2"=1'-0"